



**Dom 44 m² mieszkalny,
modułowy, całoroczny RYTEL
V2_A1
11,1 x 5,8 m, DOM MIESZKALNY
W STANIE DEWELOPERSKIM_WT
2021, Ciepła płyta
fundamentowa + system
ociepleń THERMO + stolarka 3
szybowe PVC + trzykrotne
malowana elewacja + pokrycie
dachu i orynnowanie +
instalacja elektryczna, wodno-
kanalizacyjna + wykończenie
ścian wewnętrznych, sufitów +
dostawa i montaż**

Produkt

#V2_A1_11,1x5,8_DOMMIESZKALNYWSTANIED
EWELOPERSKIM_WT2021_Ciepłapł

244130.00 zł

262450.00-zł / Zaoszczędzisz : 18320.00 zł

Najniższa cena w ciągu ostatnich 30 dni **262450.00 zł**


Cena obowiązuje przez 15 dni

<https://domyekoarchitektura.pl/dom-44-m2-mieszkalny-modulowy-caloroczny-rytel-v2-a1>




Tel.: +48 856 723 031


Kontakt mailowy: sklep@domyekoarchitektura.pl
www.domyekoarchitektura.pl

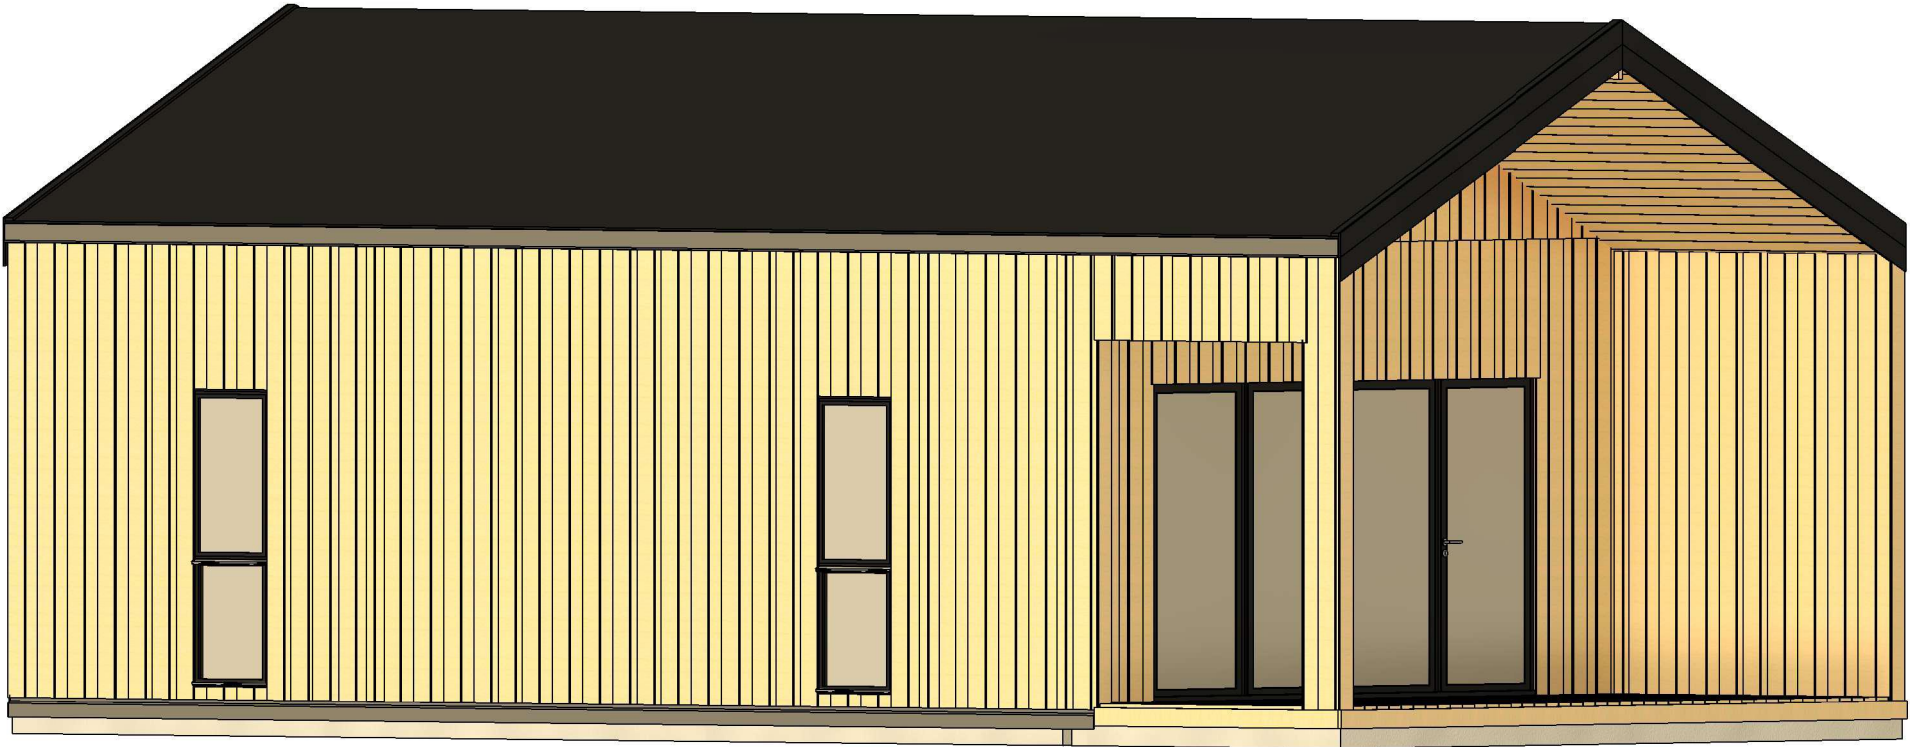

All interior area	43.5 m2	Profile	S100_A1	6/25/2024 1:04:49 PM	Project	V2_A1_THERMO_11.1x5.8_S100	Scale
All roof area	71.5 m2	All terrace	12.9 m2		Drawing name	3D VISUALIZATION	

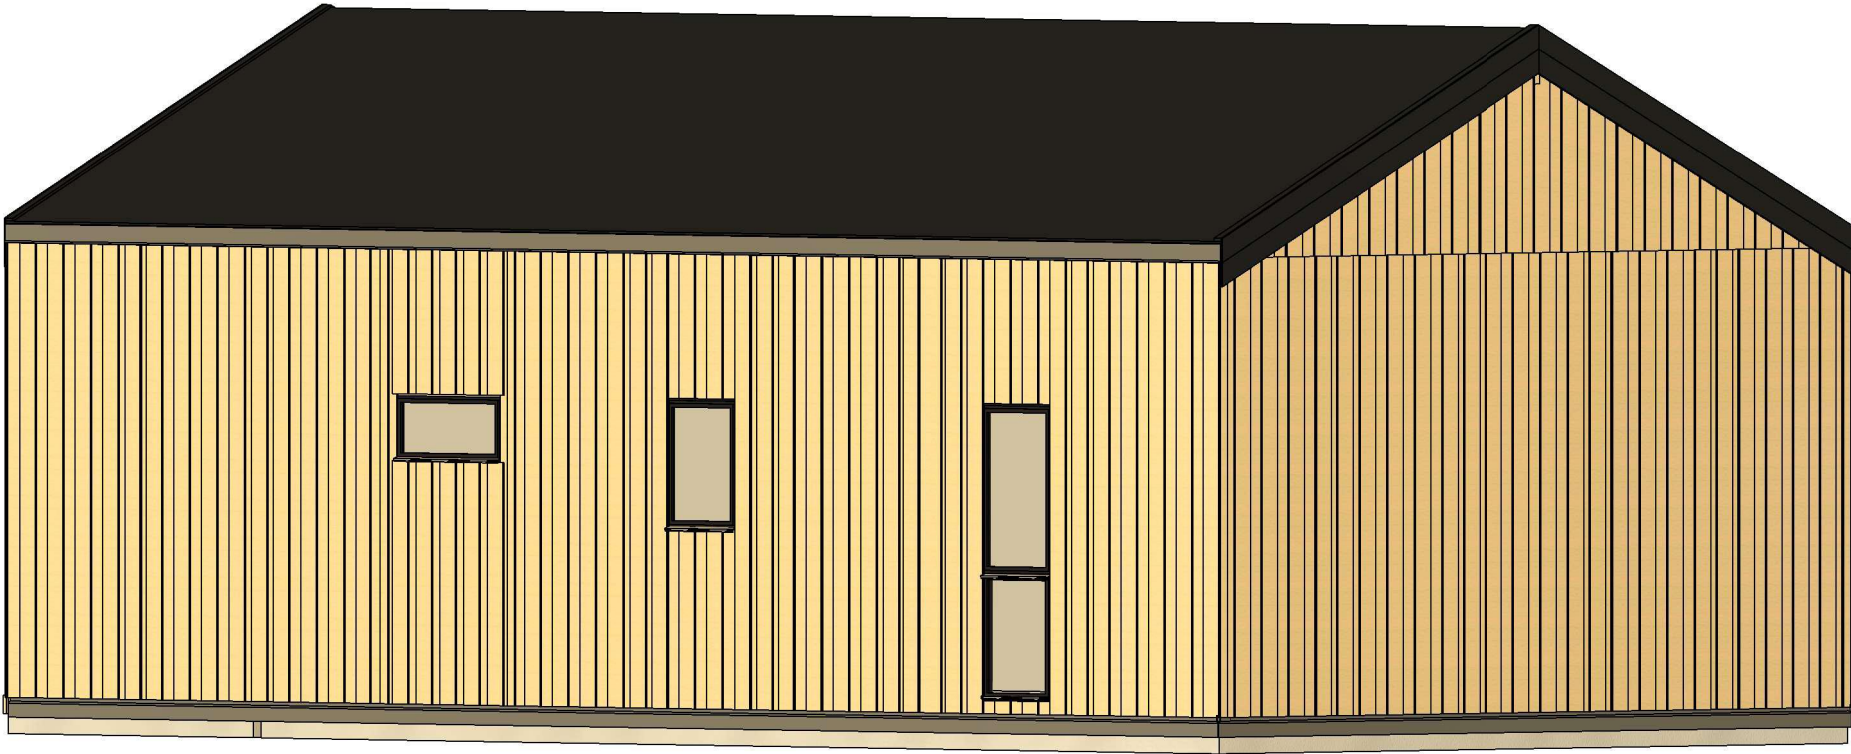


All interior area	43.5 m2	Profile	S100_A1	Project	V2_A1_THERMO_11.1x5.8_S100	Scale
All roof area	71.5 m2	All terrace	12.9 m2	6/25/2024 1:04:52 PM	Drawing name 3D VISUALIZATION	

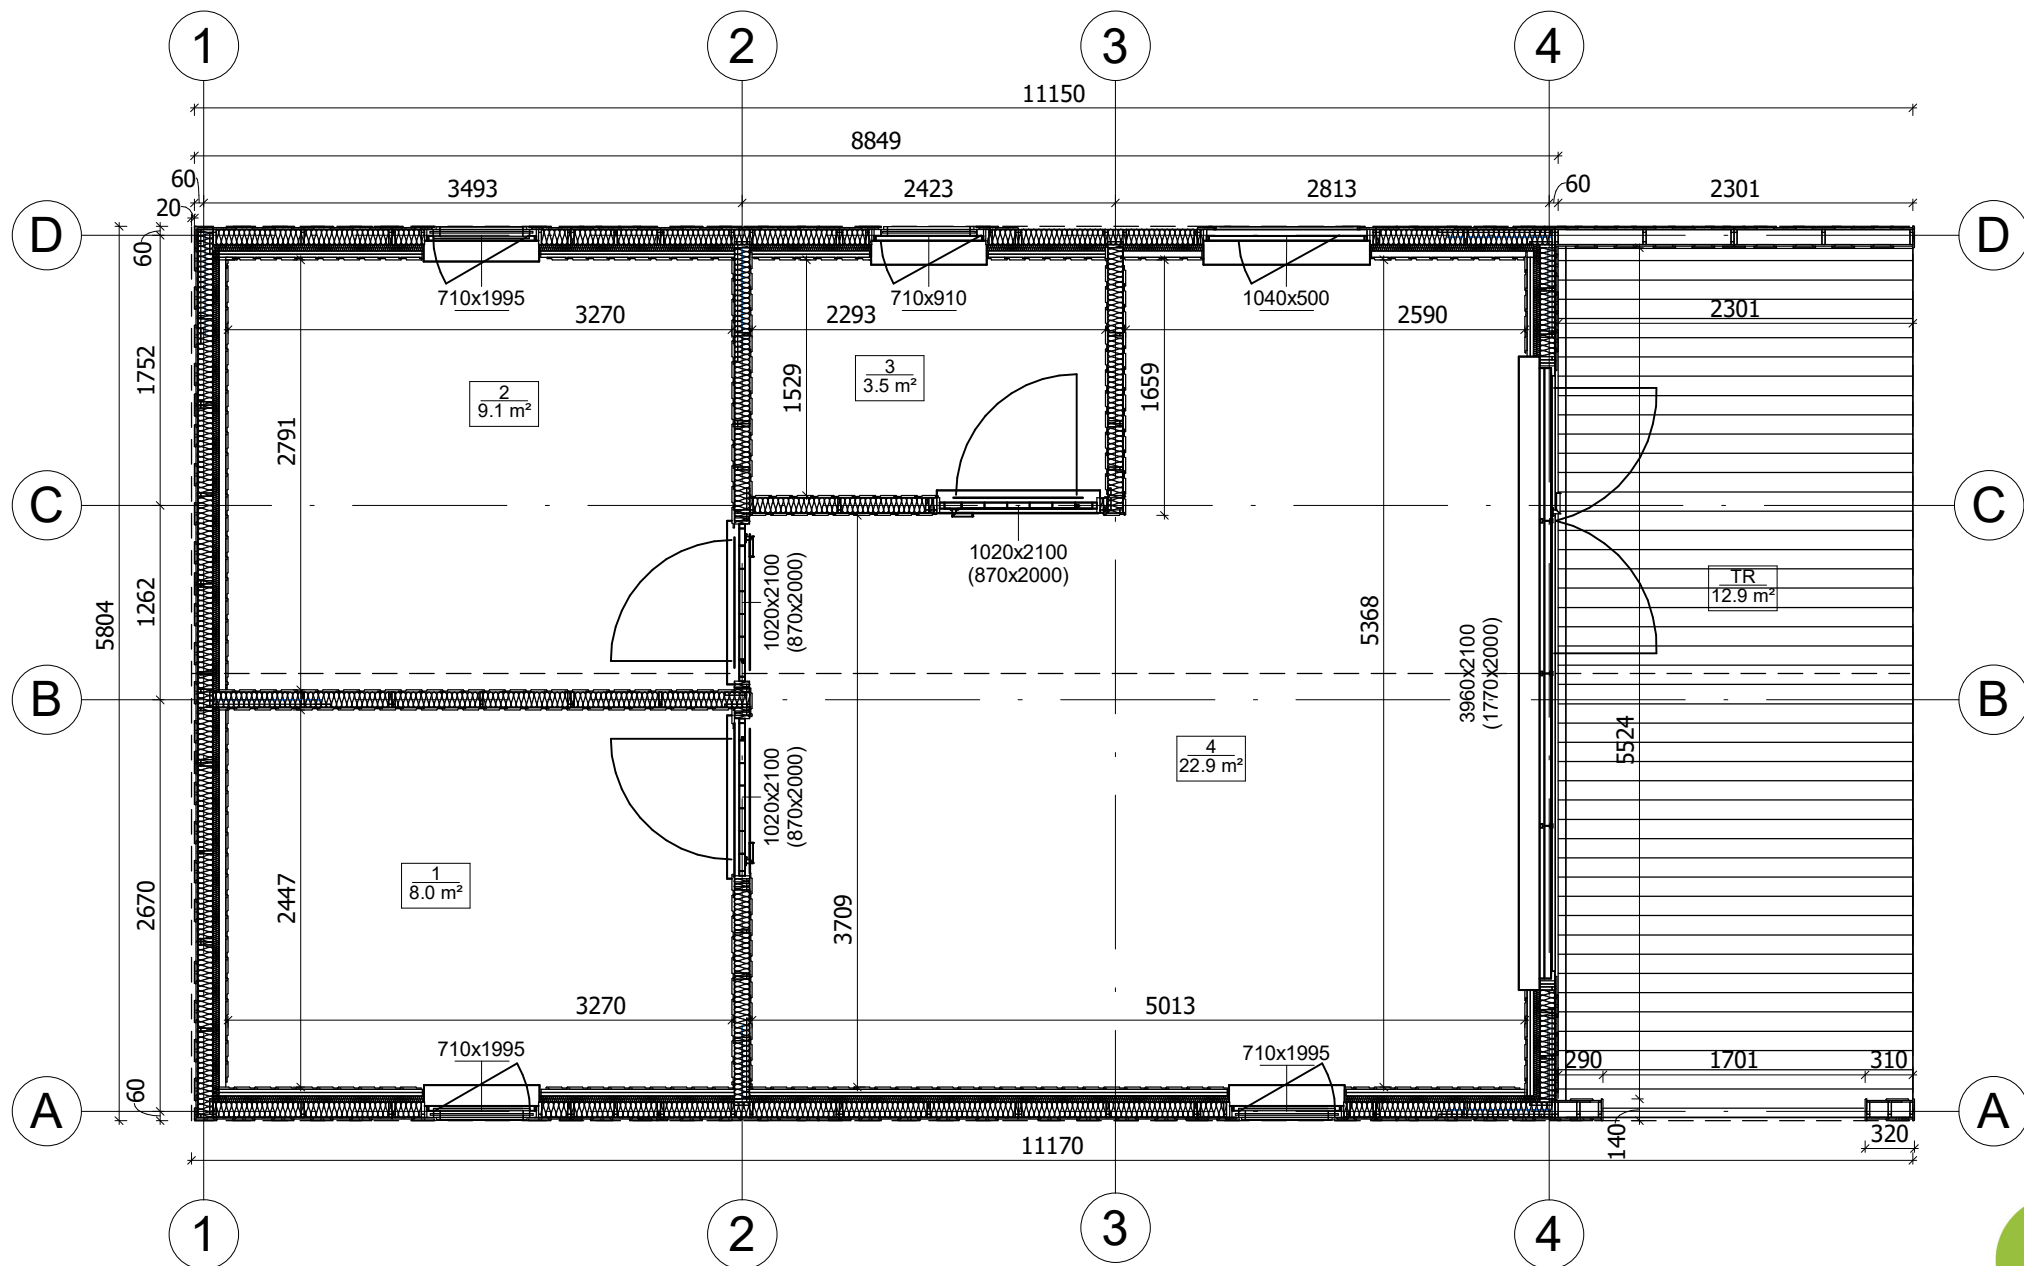


All interior area	43.5 m2	Profile	S100_A1	Project	V2_A1_THERMO_11.1x5.8_S100	Scale	
All roof area	71.5 m2	All terrace	12.9 m2	Drawing name	1 FLOOR PLAN	1 : 50	

4/8/2024
8:52:27
AM

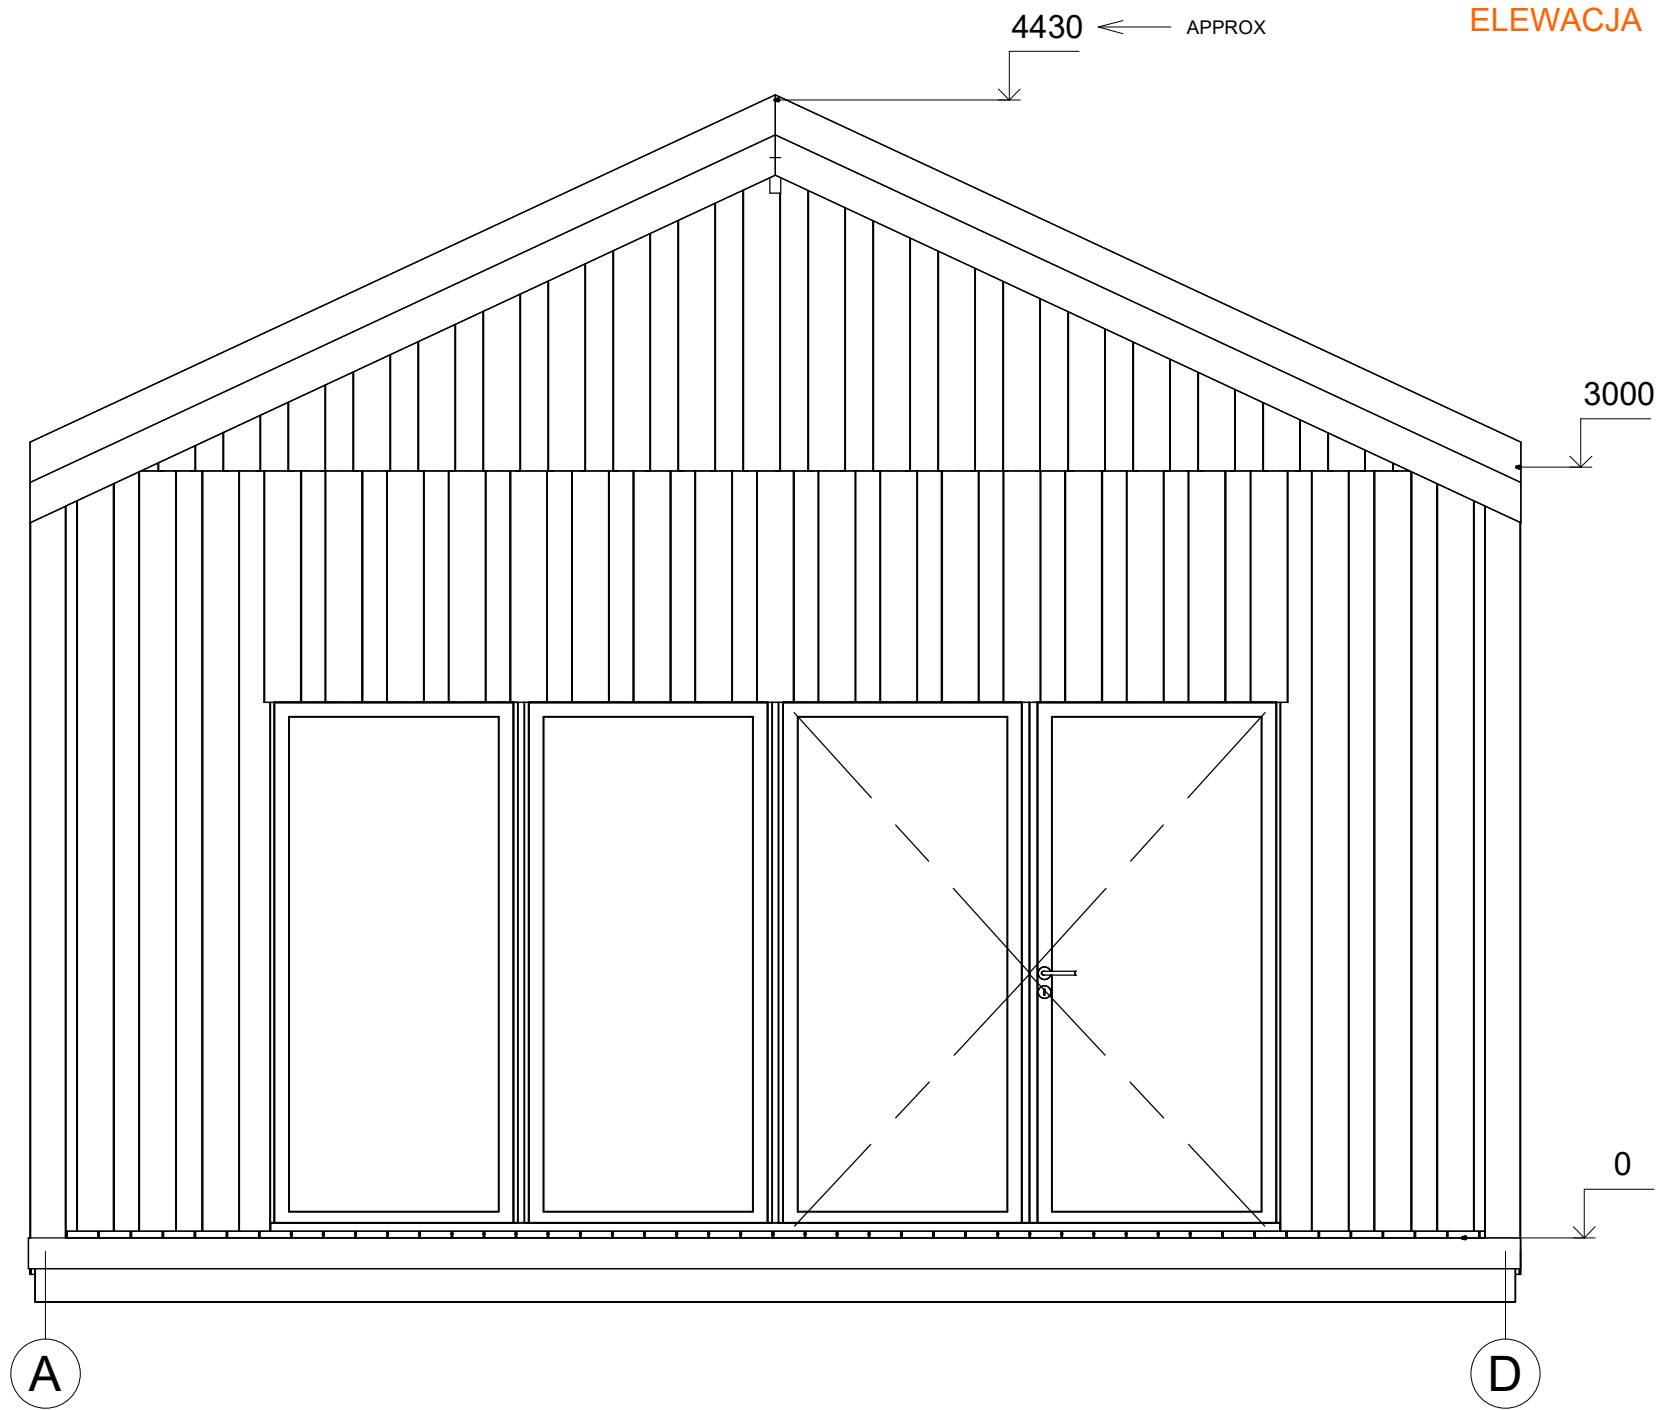


All interior area	43.5 m2	Profile	S100_A1	Project	V2_A1_THERMO_11.1x5.8_S100	Scale
All roof area	71.5 m2	All terrace	12.9 m2	6/25/2024 2:24:15 PM	Drawing name	FACADE AD
						1 : 30


ELEWACJA

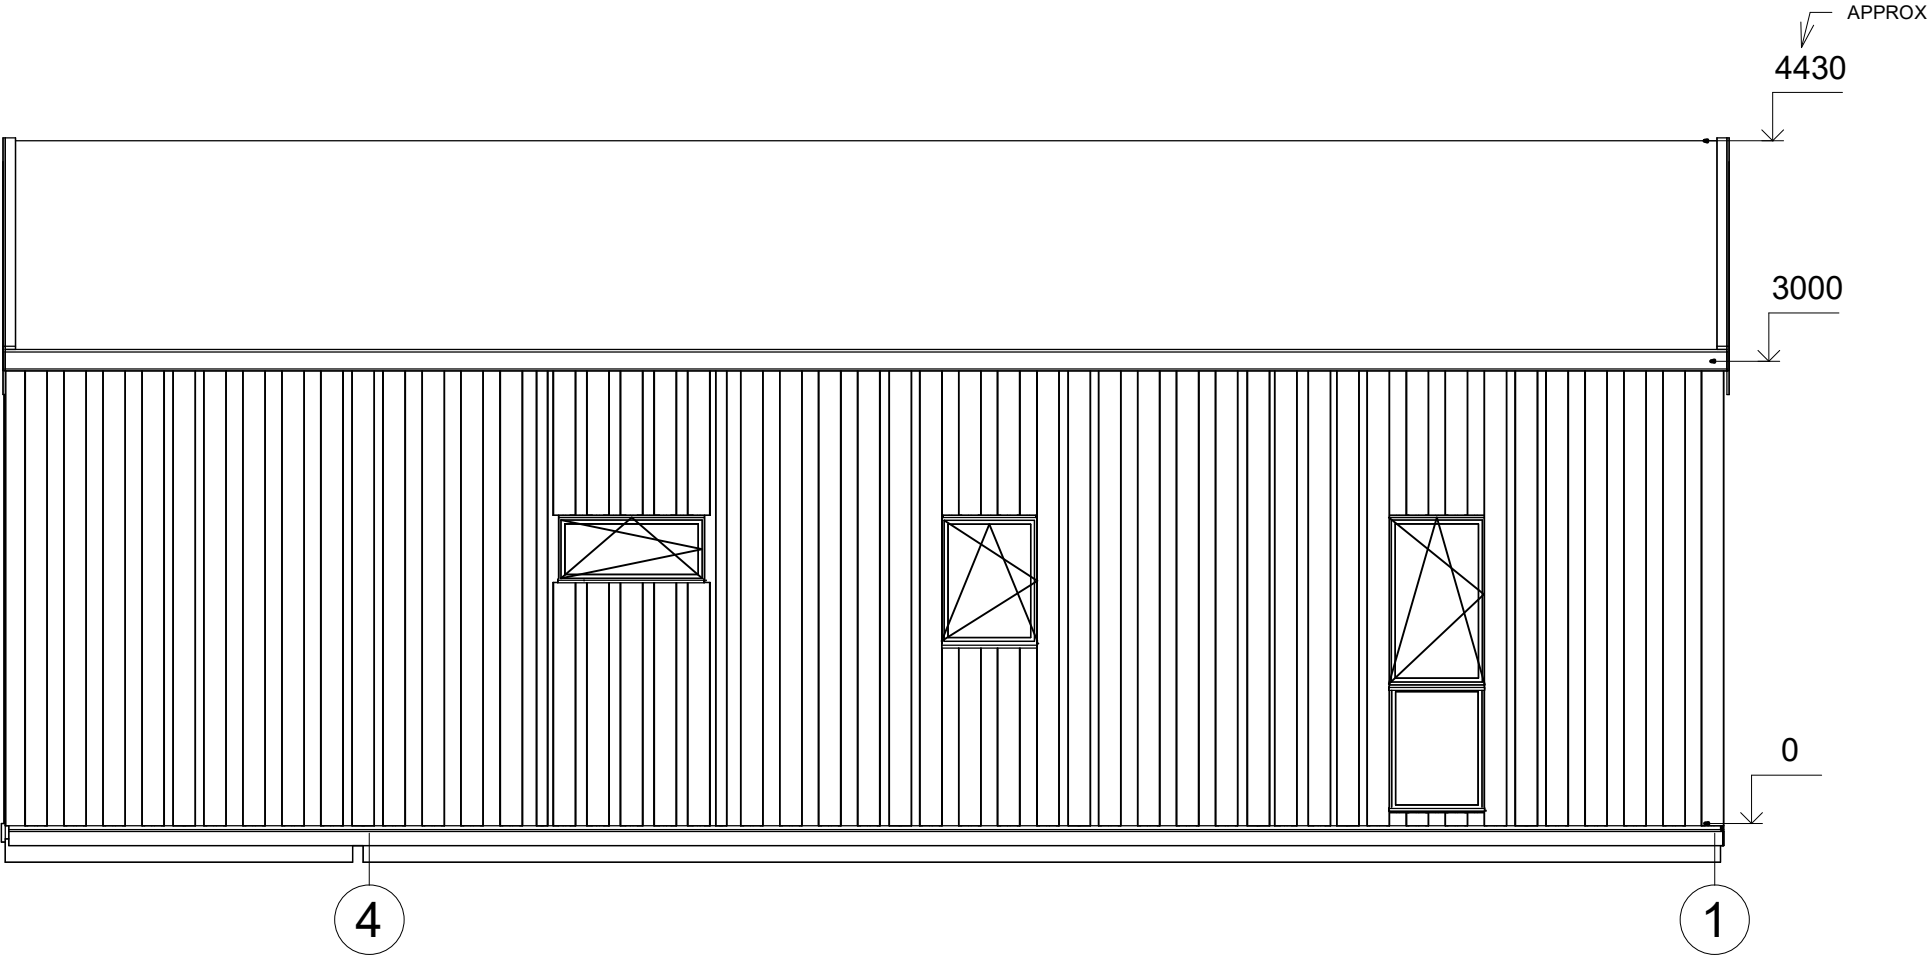

All interior area	43.5 m2	Profile	S100_A1	Project	V2_A1_THERMO_11.1x5.8_S100	Scale
All roof area	71.5 m2	All terrace	12.9 m2	6/25/2024 2:24:16 PM	Drawing name	FACADE 41
						1 : 50

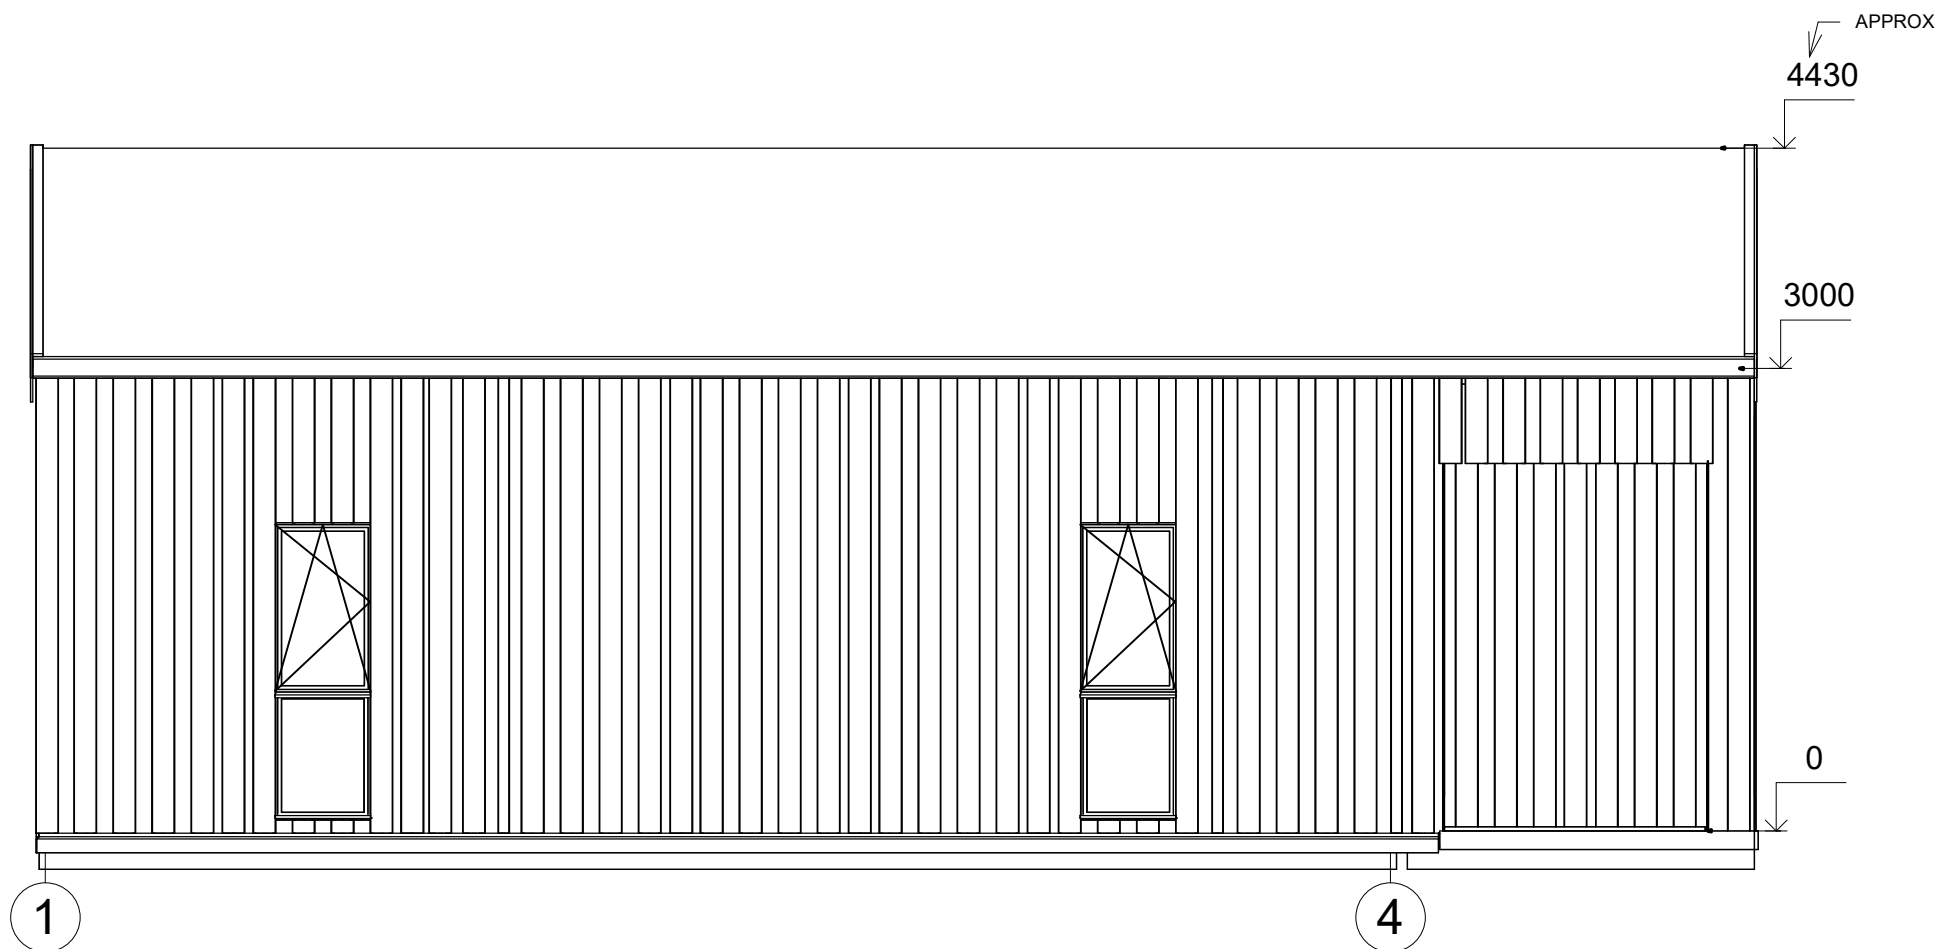


All interior area	43.5 m2	Profile	S100_A1	Project	V2_A1_THERMO_11.1x5.8_S100	Scale
All roof area	71.5 m2	All terrace	12.9 m2	6/25/2024 2:24:17 PM	Drawing name	FACADE 14
						1 : 50

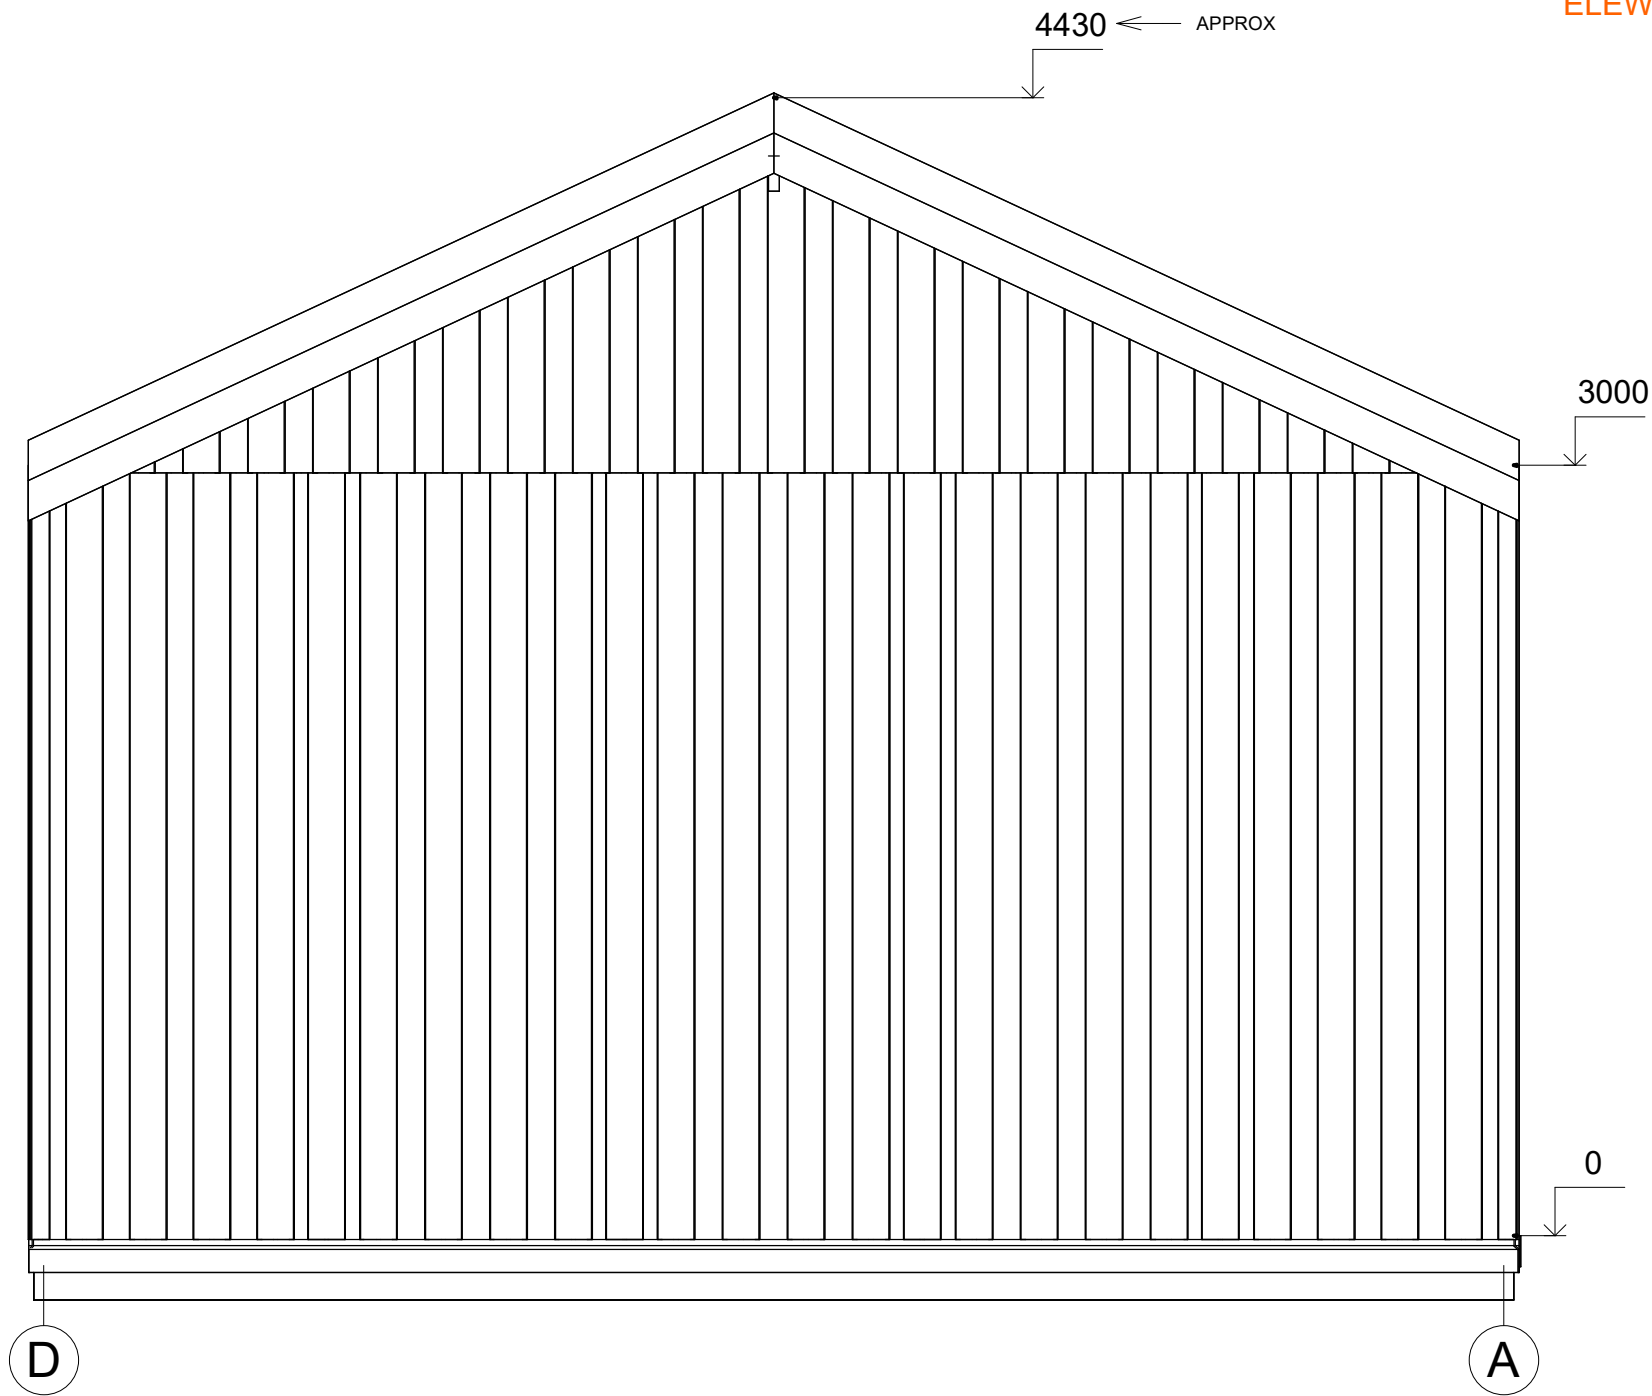

All interior area	43.5 m2	Profile	S100_A1	Project	V2_A1_THERMO_11.1x5.8_S100	Scale
All roof area	71.5 m2	All terrace	12.9 m2	Drawing name	FACADE DA	1 : 30

PRZEKROJ

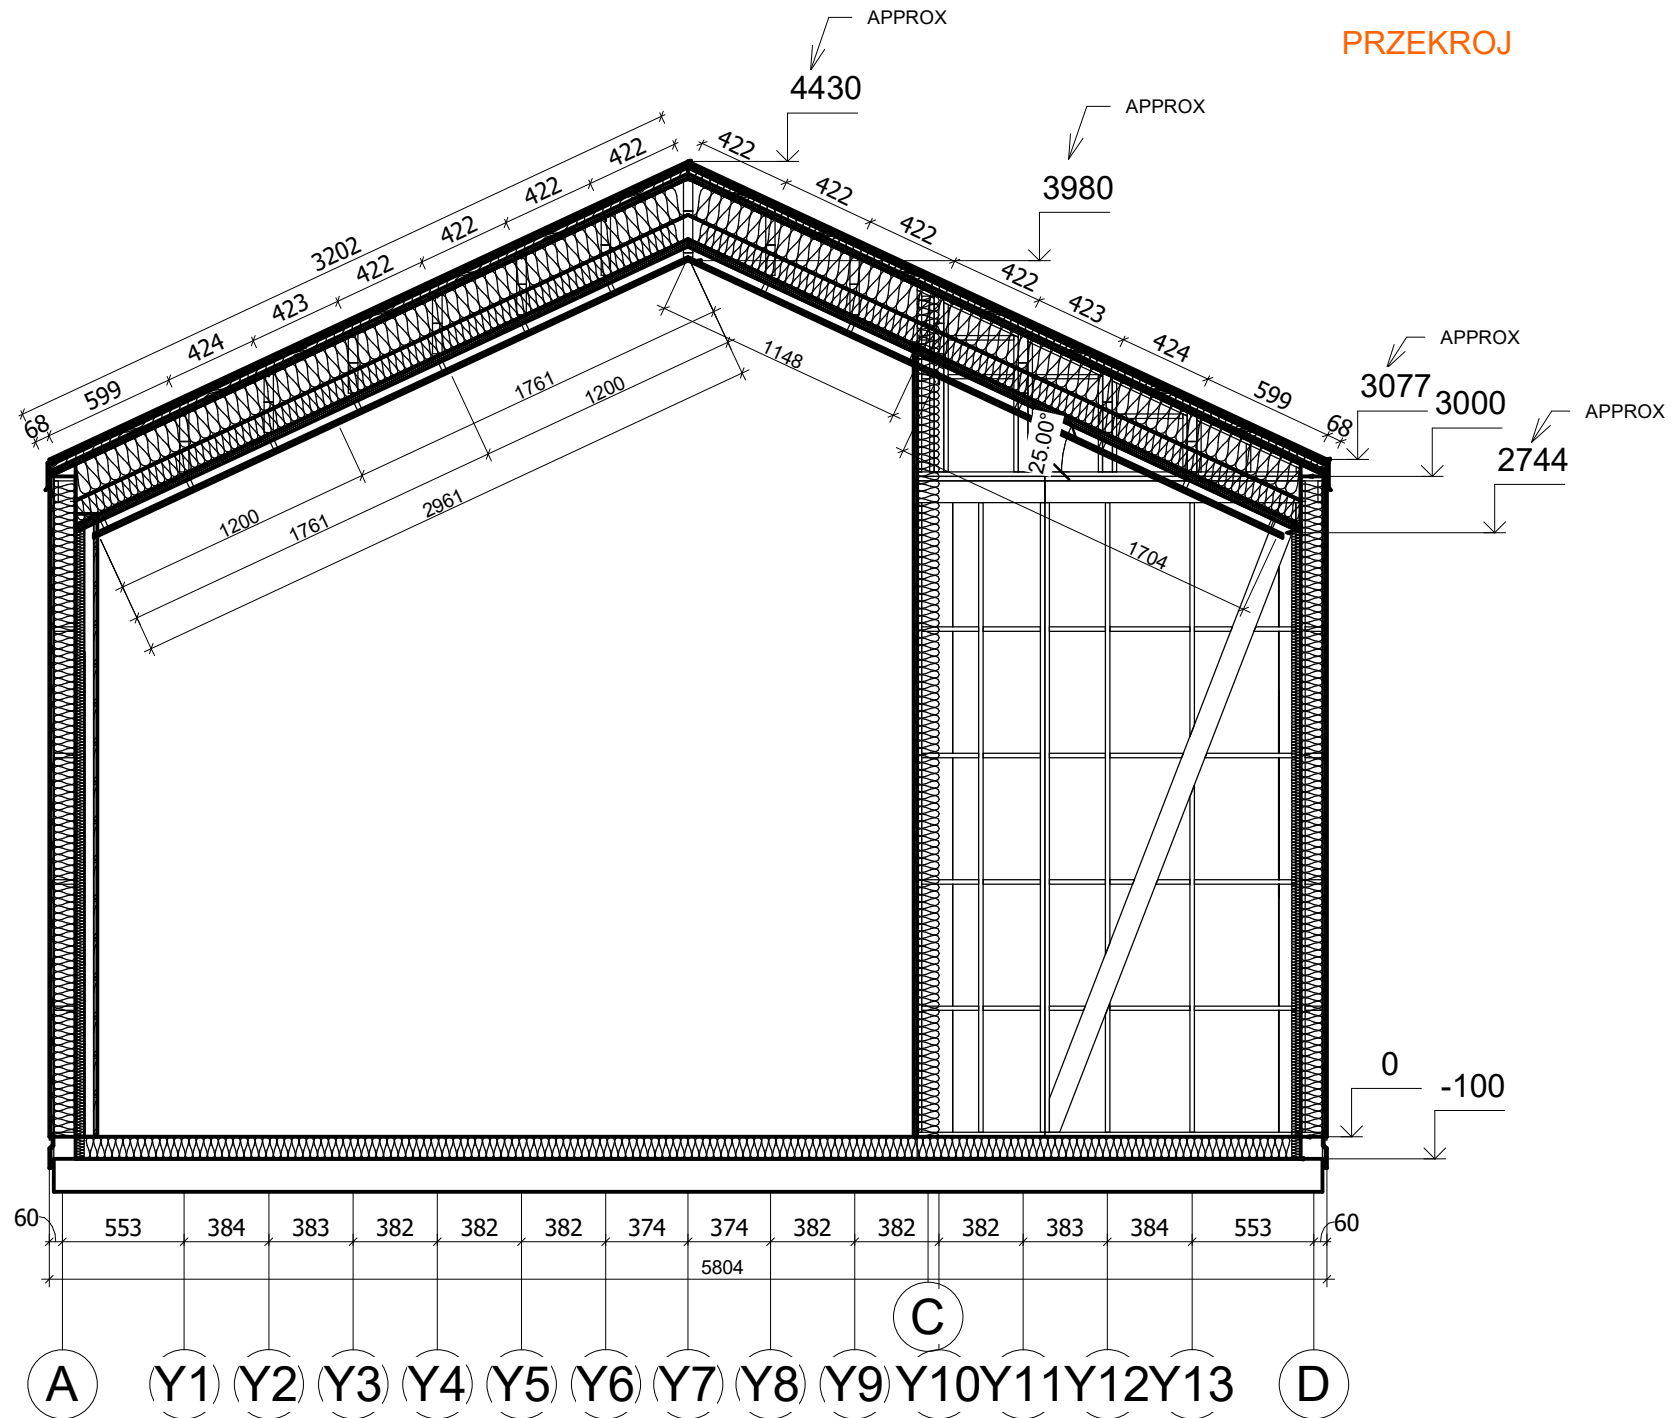

All interior area	43.5 m2	Profile S100_A1		Project V2_A1_THERMO_11.1x5.8_S100	Scale
All roof area	71.5 m2	All terrace	12.9 m2	Drawing name VERTICAL SECTION 3-AD	