



**Domek całoroczny 30 m²
modułowy RETNO V1_A1
4.06 x 5.36 m, DOM
MIESZKALNY W STANIE
DEWELOPERSKIM_WT 2021,
Ciepła płyta fundamentowa +
system ociepleń THERMO +
stolarka 3 szybowe PVC +
trzykrotnie malowana elewacja +
pokrycie dachu i orynnowanie +
instalacja elektryczna, wodno-
kanalizacyjna + wykończenie
ścian wewnętrznych, sufitów +
dostawa i montaż**

Produkt

#V1_A1_4.06x5.36_DOMMIESZKALNYWSTANIE
DEWELOPERSKIM_WT2021_Cieplap

116800.00 zł

<https://domyekoarchitektura.pl/domek-caloroczny-30-m2-modulowy-retno-v1-a1>




Tel.: +48 856 723 031


Kontakt mailowy: sklep@domyekoarchitektura.pl
www.domyekoarchitektura.pl




All interior area	28.8 m2	Profile	S100_A1	Project	V1_A1_THERMO_4x5.3_S100	Scale
All roof area	35.0 m2	All terrace	1.7 m2	2023-01-18 09:42:20	Drawing name 3D VISUALIZATION	

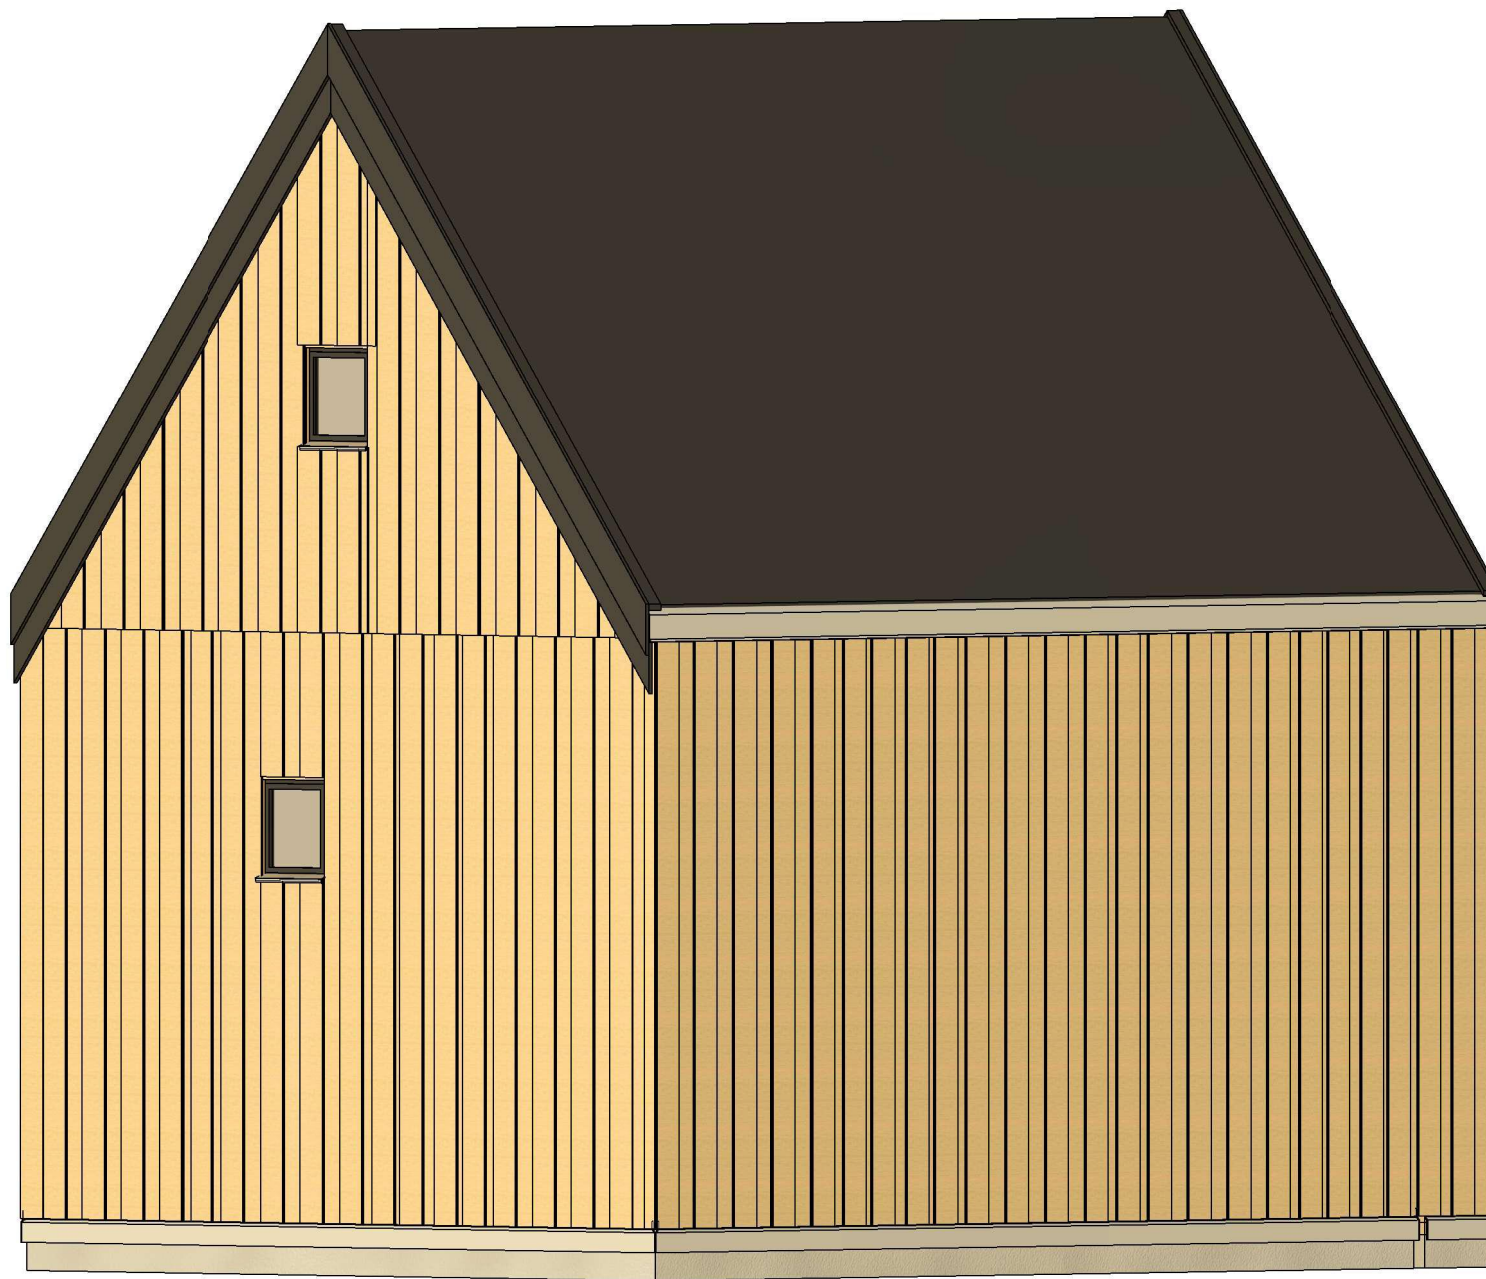


All interior area	28.8 m2	Profile	S100_A1	Project	V1_A1_THERMO_4x5.3_S100	Scale
All roof area	35.0 m2	All terrace	1.7 m2	2023-01-18 09:42:23	Drawing name 3D VISUALIZATION	

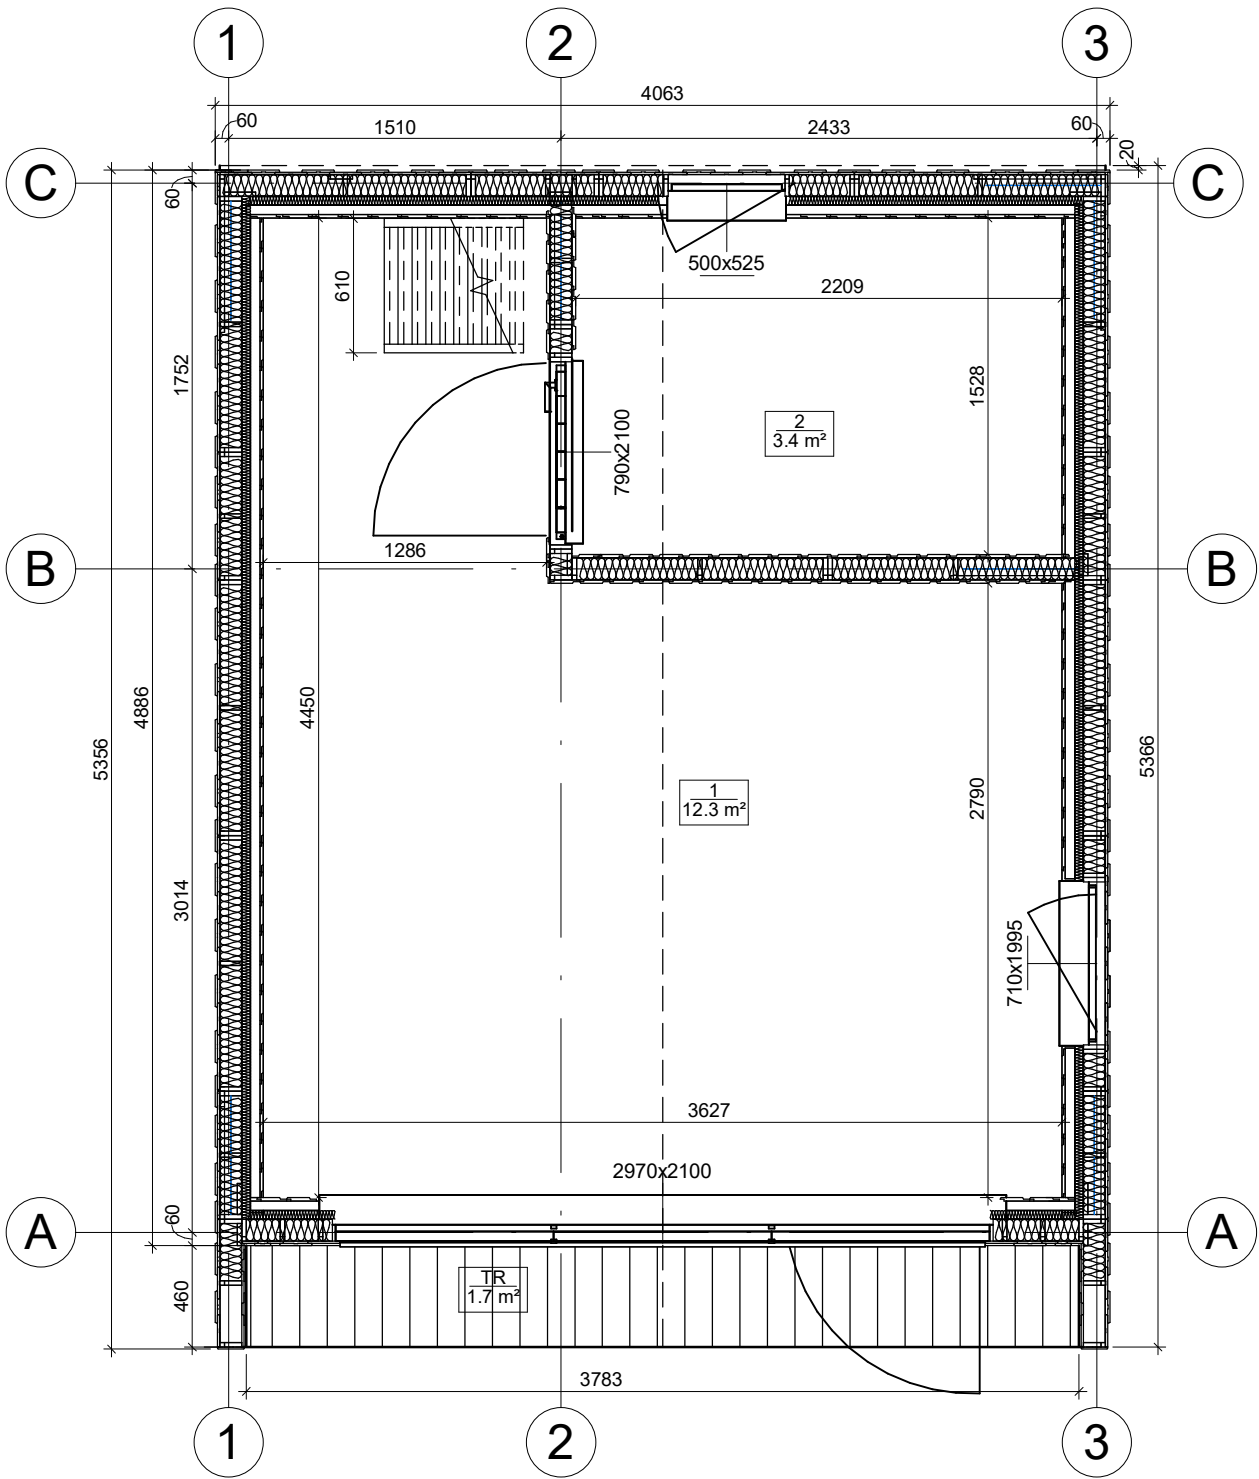


All interior area	28.8 m2	Profile	S100_A1	Project	V1_A1_THERMO_4x5.3_S100	Scale
All roof area	35.0 m2	All terrace	1.7 m2	7/10/2023 8:23:38 AM	Drawing name	1 FLOOR PLAN
						1 : 35

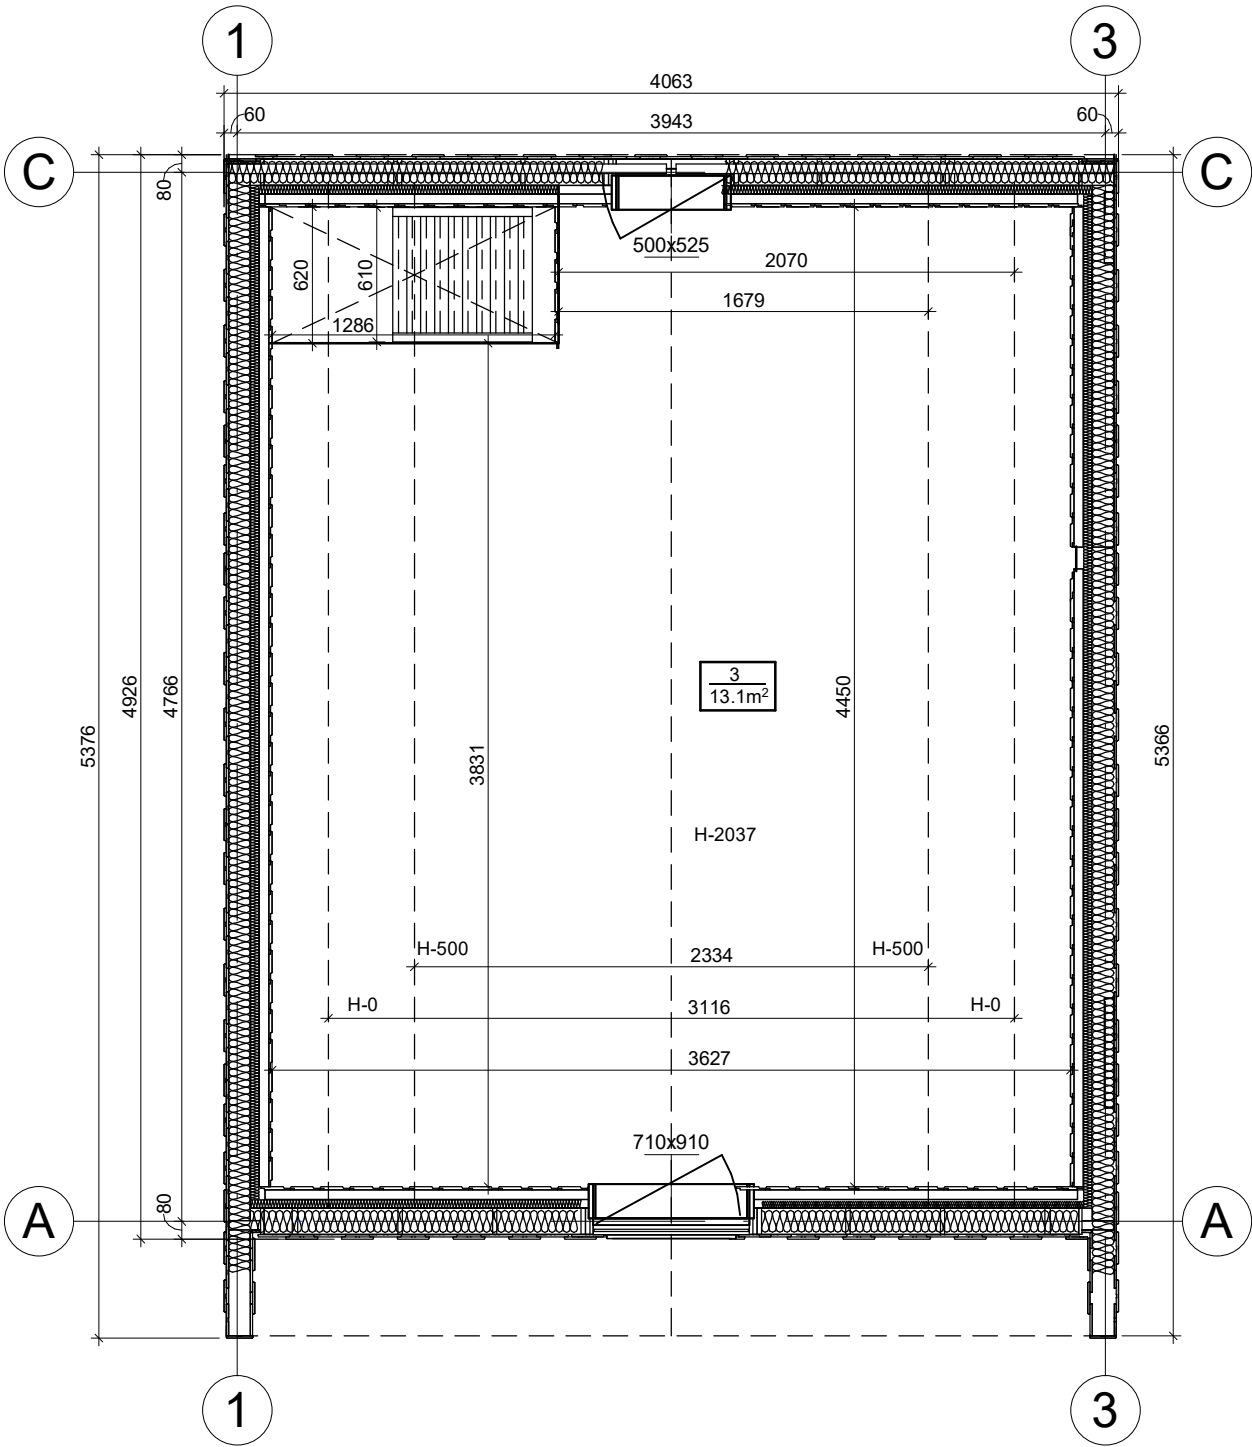


All interior area	28.8 m2	Profile	S100_A1	Project	V1_A1_THERMO_4x5.3_S100	Scale
All roof area	35.0 m2	All terrace	1.7 m2	Drawing name	2 FLOOR PLAN	1 : 35
		7/10/2023 8:23:39 AM				

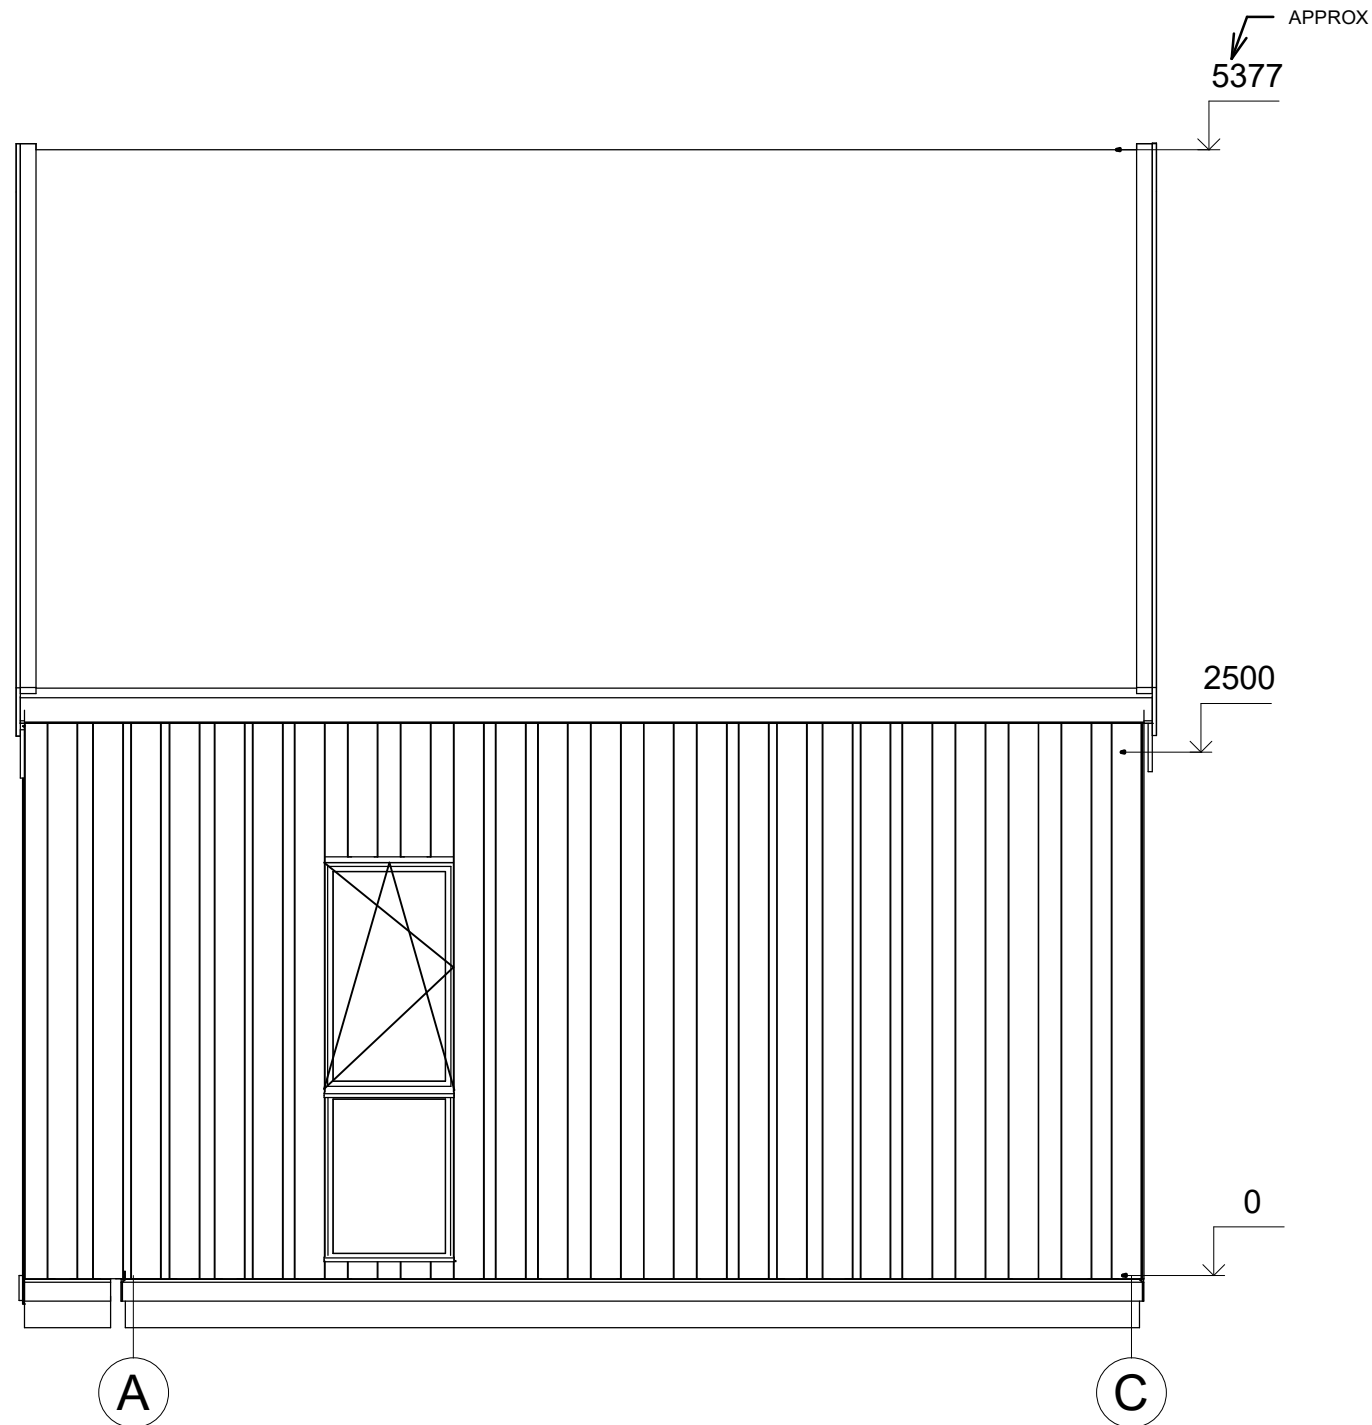


All interior area	28.8 m2	Profile	S100_A1	Project	V1_A1_THERMO_4x5.3_S100	Scale
All roof area	35.0 m2	All terrace	1.7 m2	2023-01-16 19:40:58	Drawing name	FACADE AC
						1 : 37

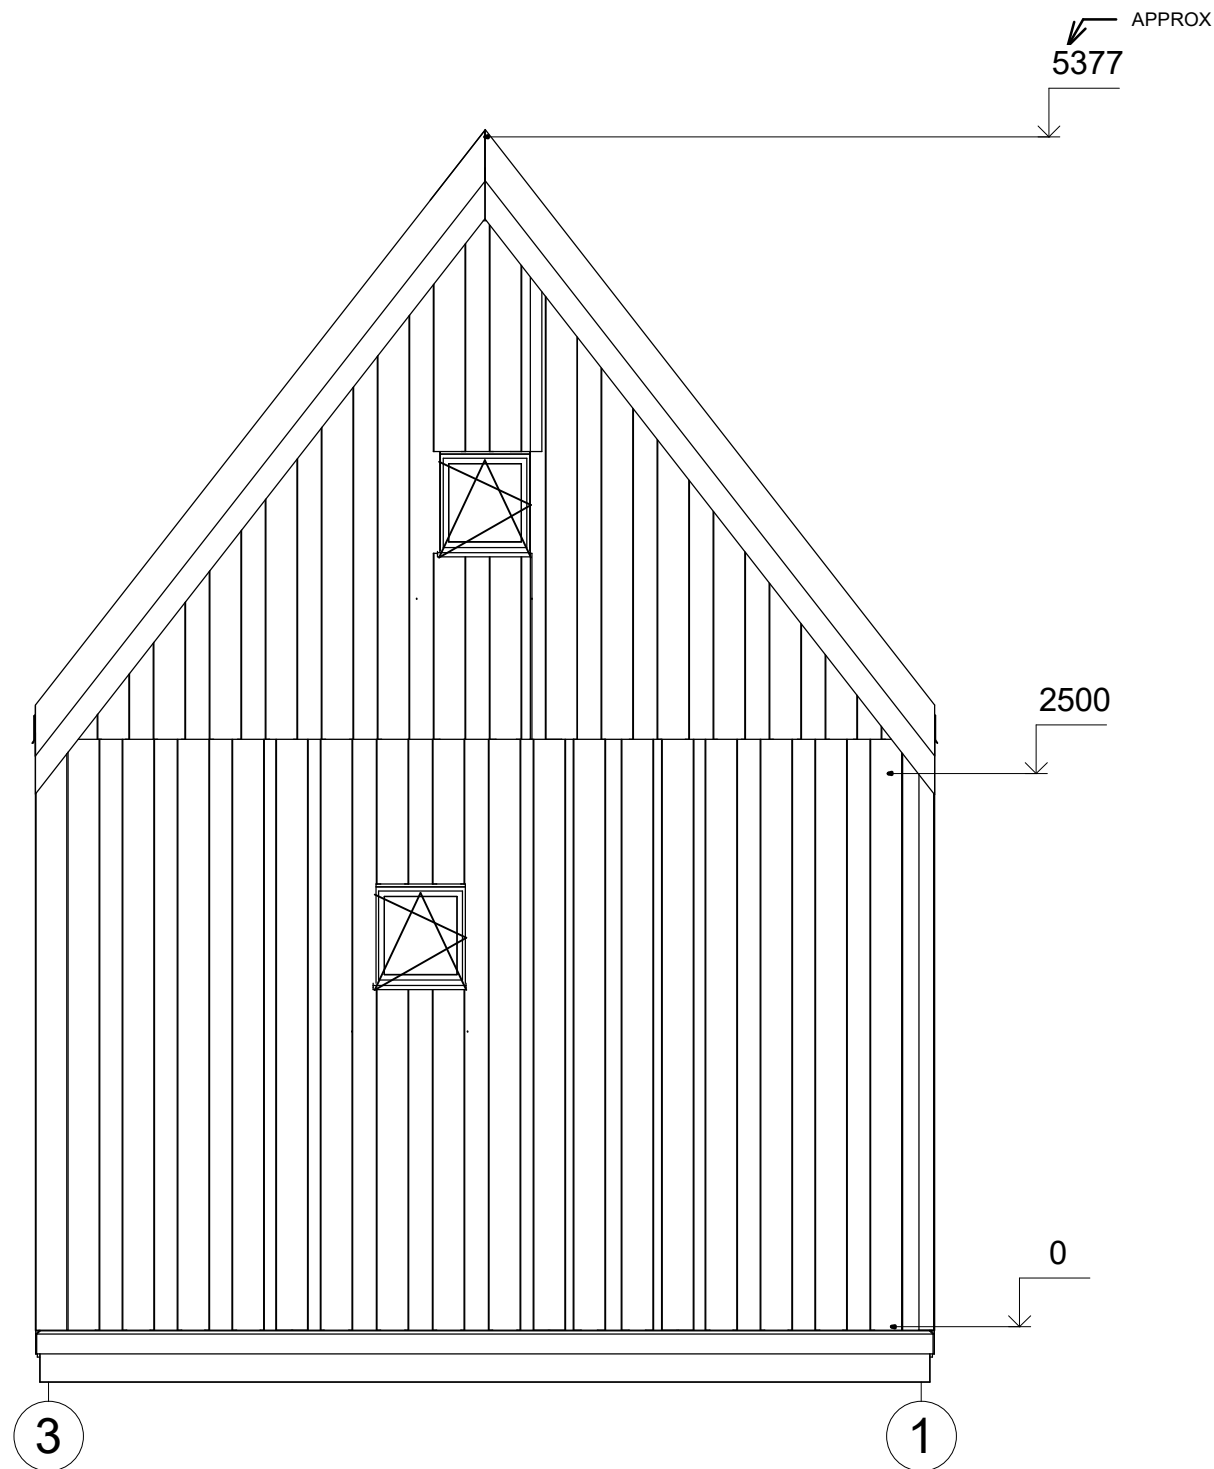


All interior area	28.8 m2	Profile	S100_A1	Project	V1_A1_THERMO_4x5.3_S100	Scale
All roof area	35.0 m2	All terrace	1.7 m2	2023-01-16 19:40:58	Drawing name	FACADE 31
						1 : 35

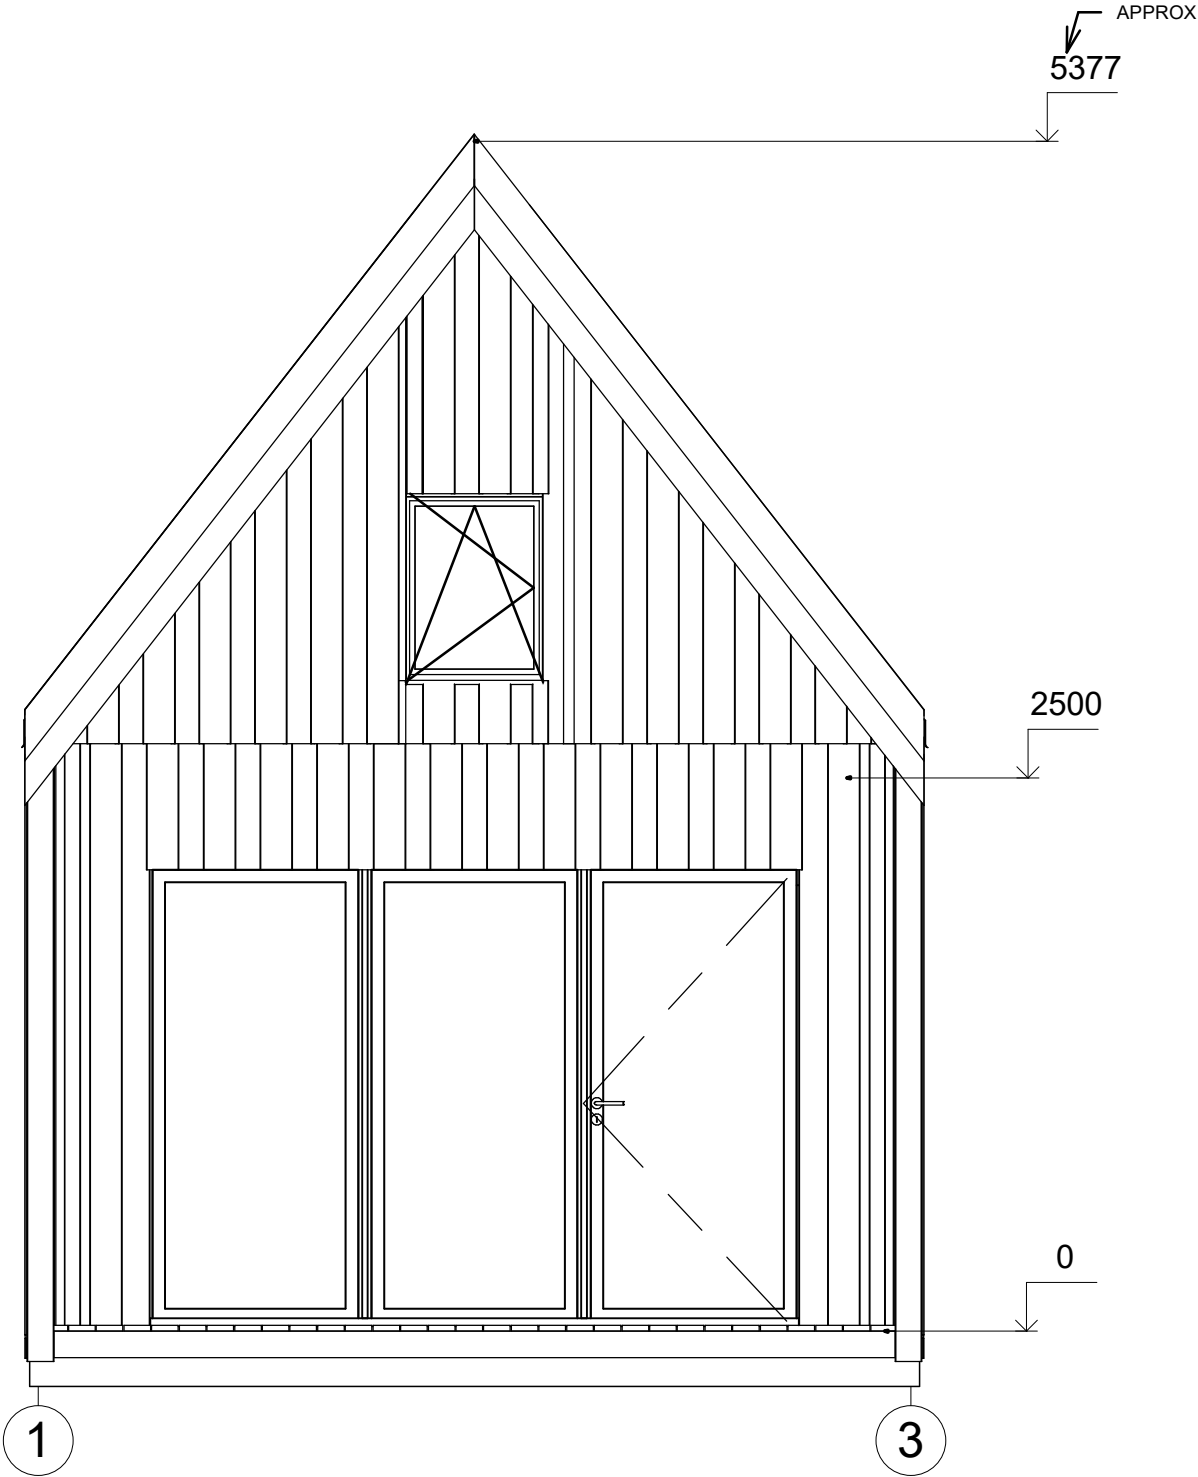


All interior area	28.8 m2	Profile	S100_A1	Project	V1_A1_THERMO_4x5.3_S100	Scale
All roof area	35.0 m2	All terrace	1.7 m2	2023-01-16 19:40:58	Drawing name	FACADE 13
						1 : 35

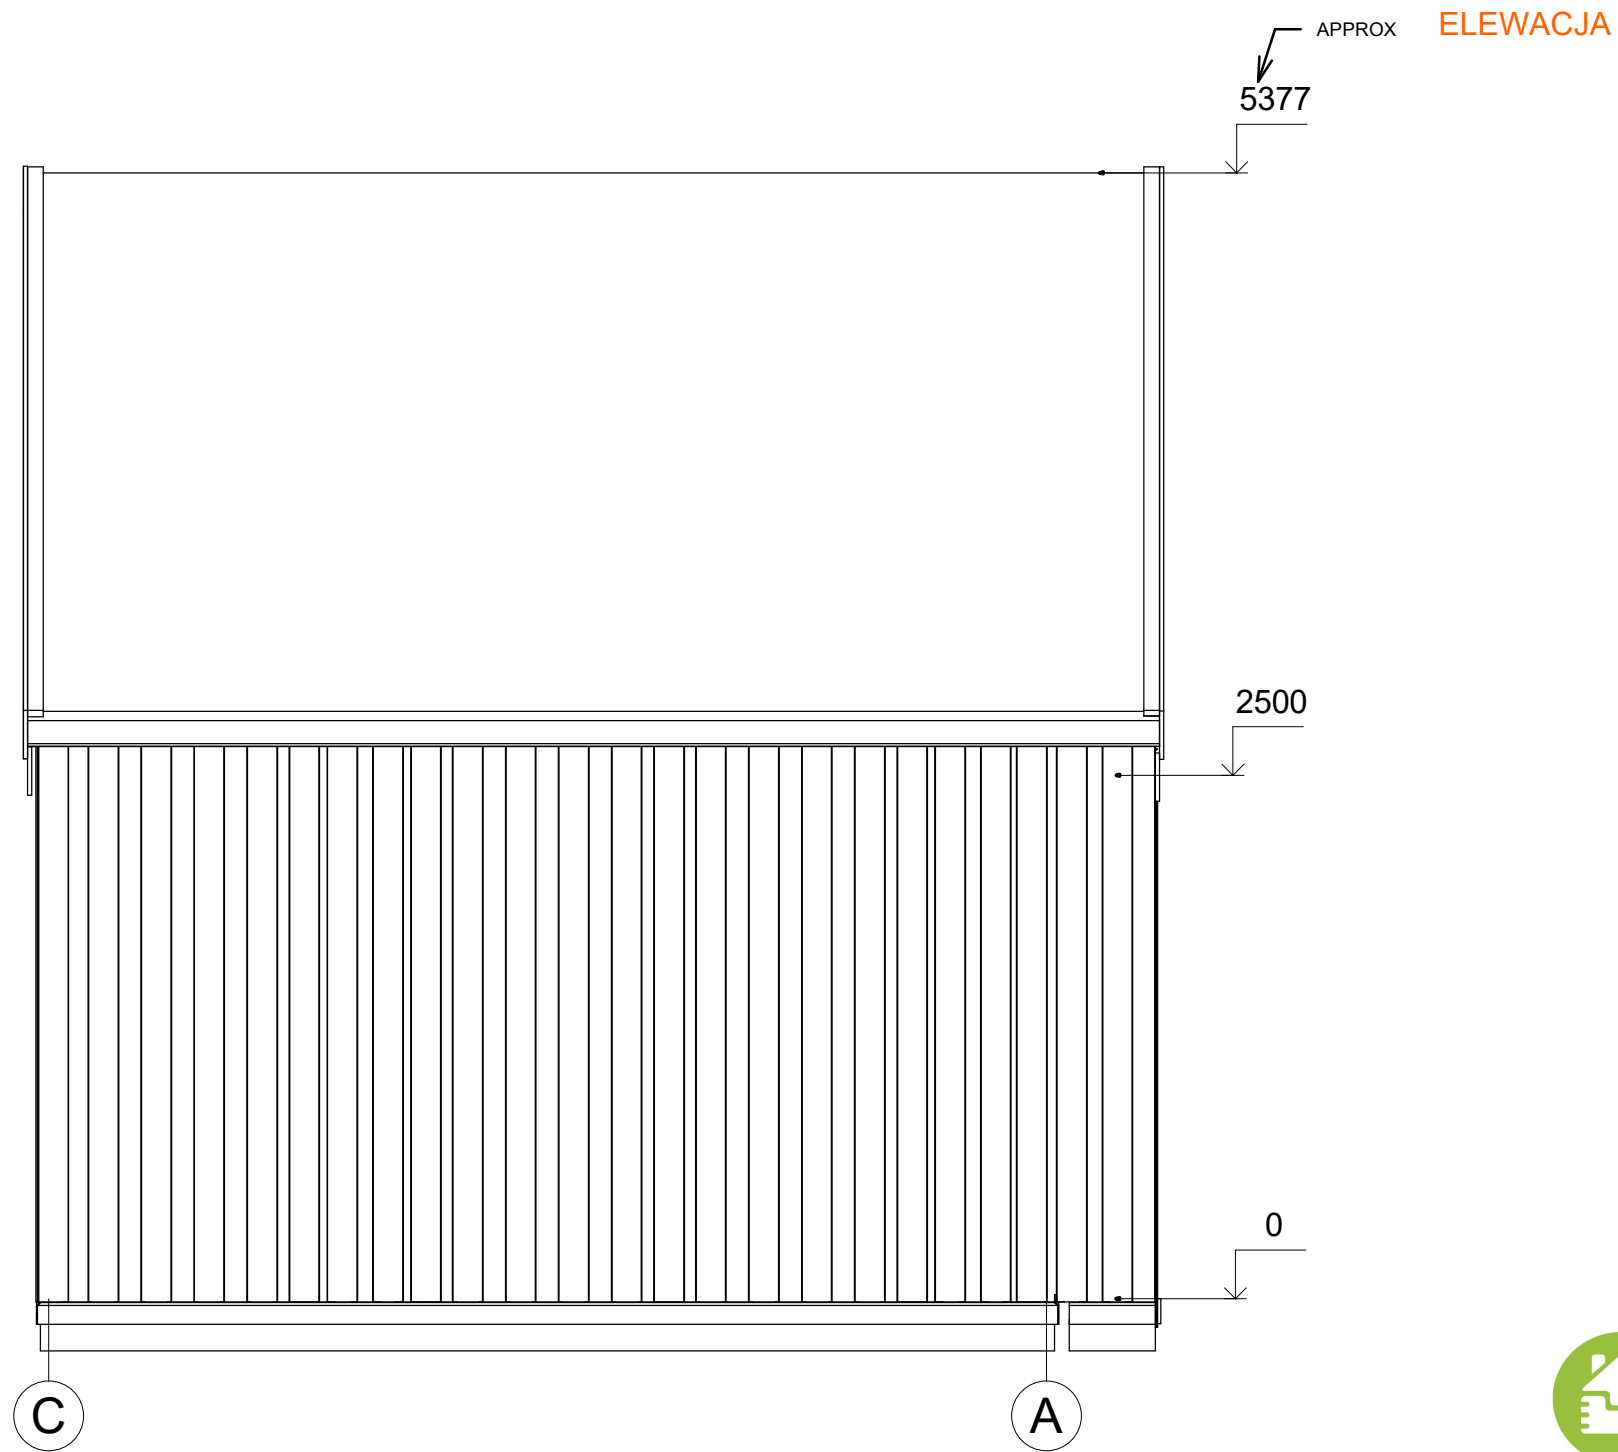


All interior area	28.8 m2	Profile	S100_A1	Project	V1_A1_THERMO_4x5.3_S100	Scale
All roof area	35.0 m2	All terrace	1.7 m2	2023-01-16 19:40:58	Drawing name	FACADE CA
						1 : 37

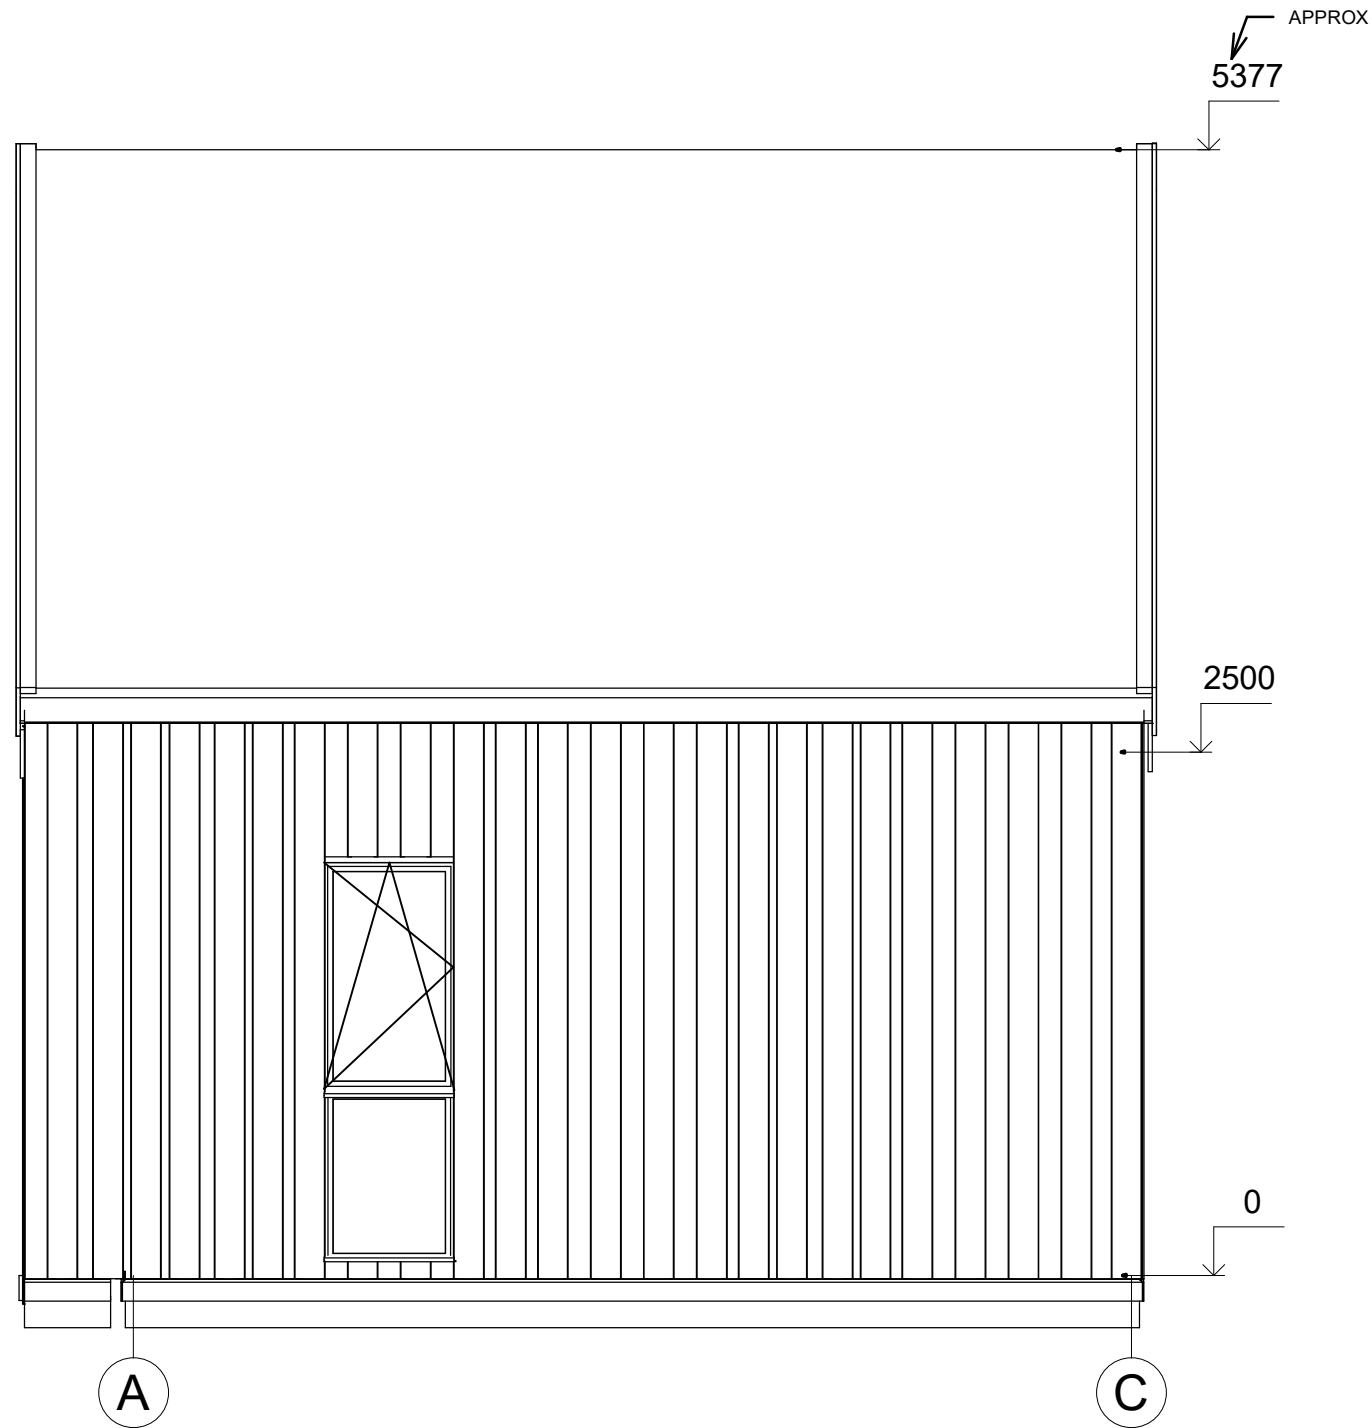


All interior area	28.8 m2	Profile	S100_A1	Project	V1_A1_THERMO_4x5.3_S100	Scale
All roof area	35.0 m2	All terrace	1.7 m2	2023-01-16 19:40:58	Drawing name	FACADE AC
						1 : 37

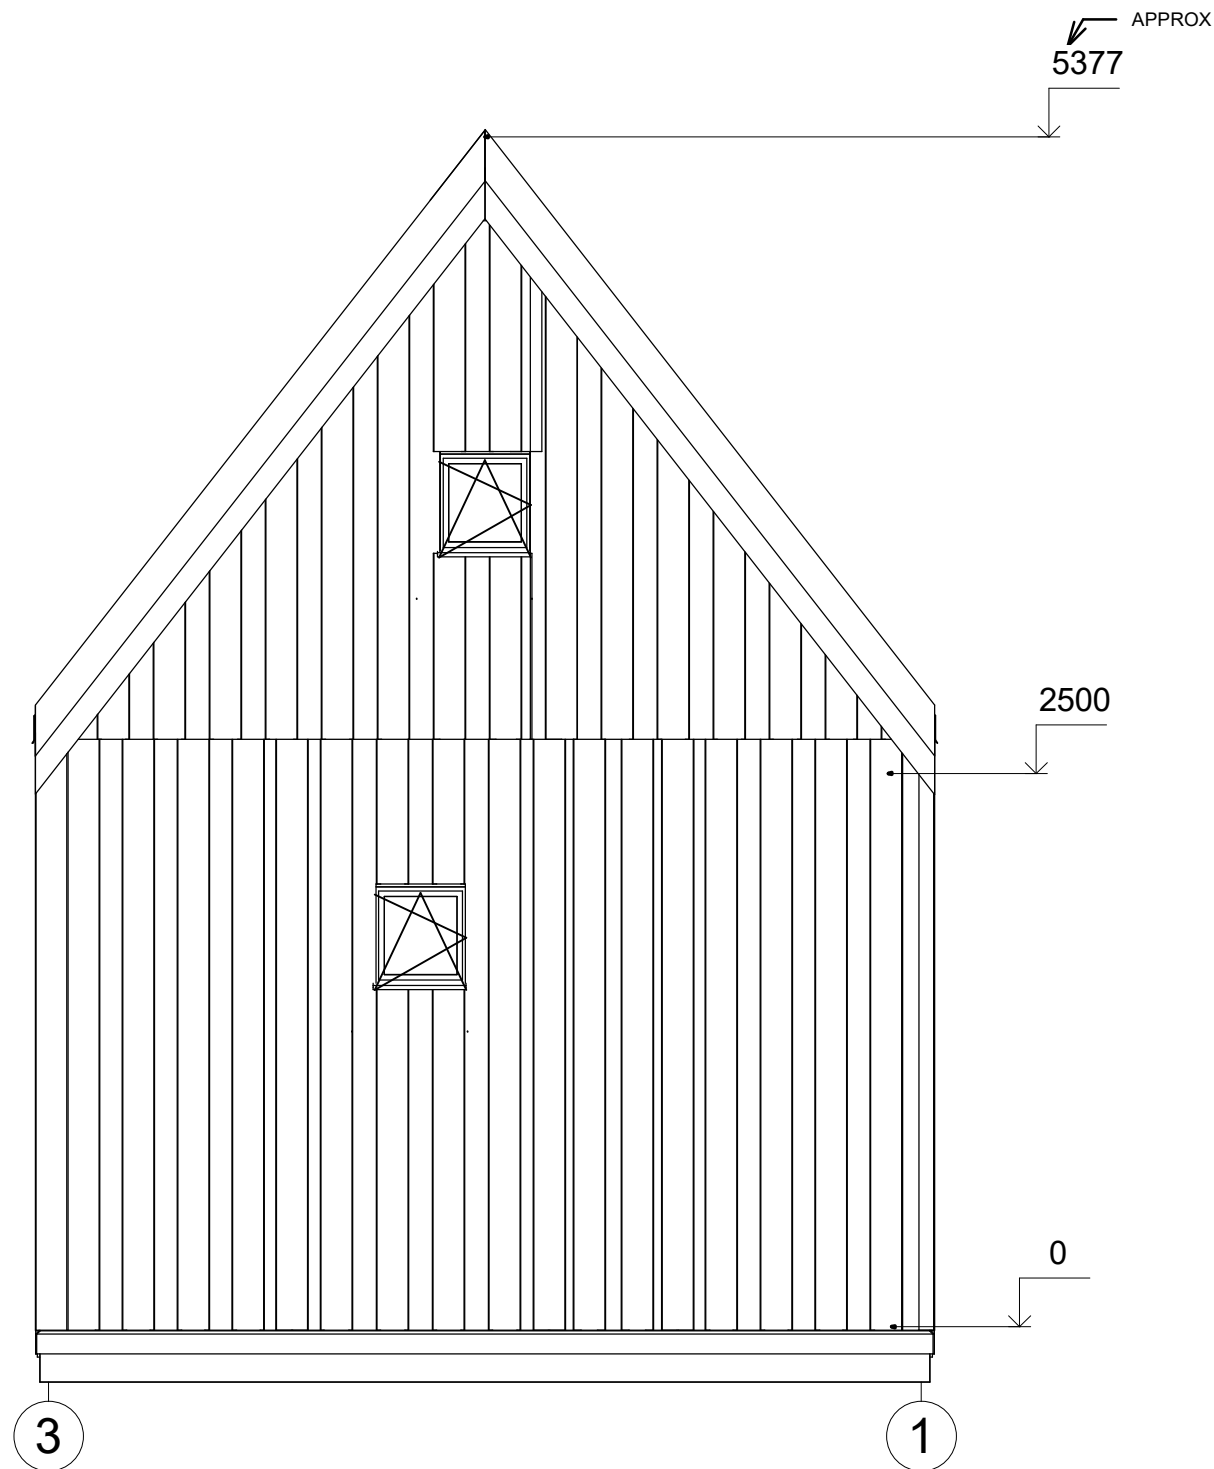

All interior area	28.8 m2	Profile	S100_A1	Project	V1_A1_THERMO_4x5.3_S100	Scale
All roof area	35.0 m2	All terrace	1.7 m2	2023-01-16 19:40:58	Drawing name	FACADE 31
						1 : 35

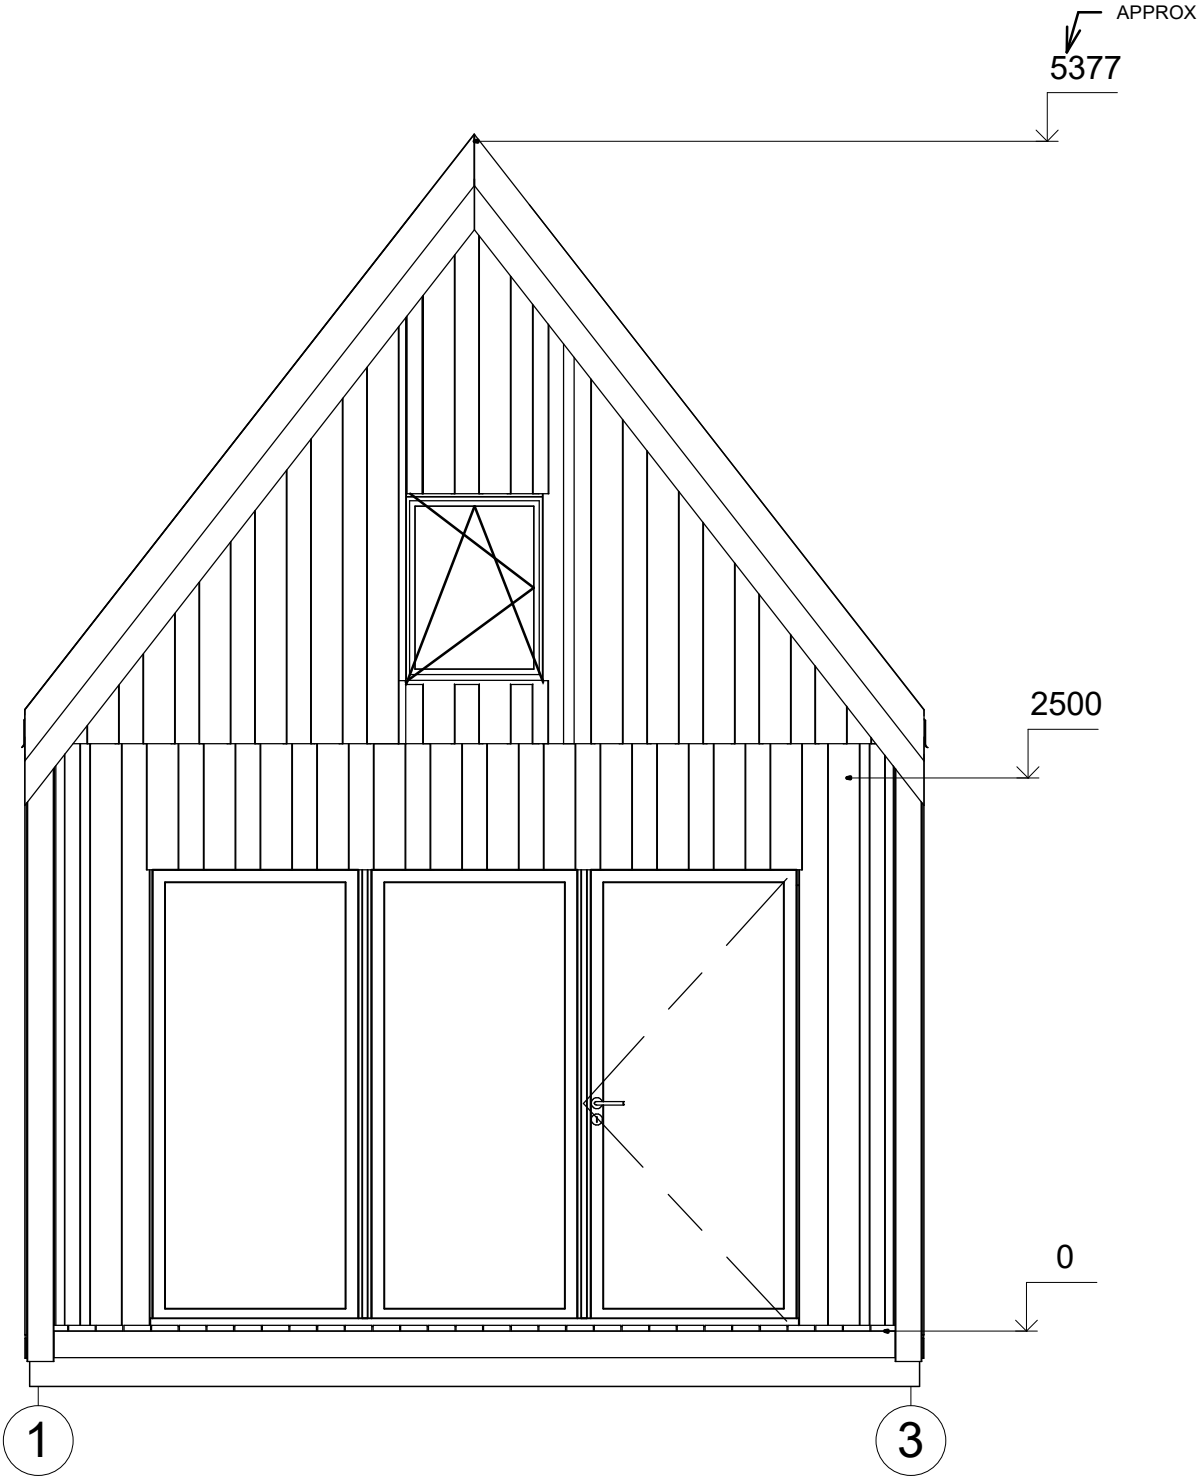

All interior area	28.8 m2	Profile	S100_A1	Project	V1_A1_THERMO_4x5.3_S100	Scale
All roof area	35.0 m2	All terrace	1.7 m2	2023-01-16 19:40:58	Drawing name	FACADE 13
						1 : 35

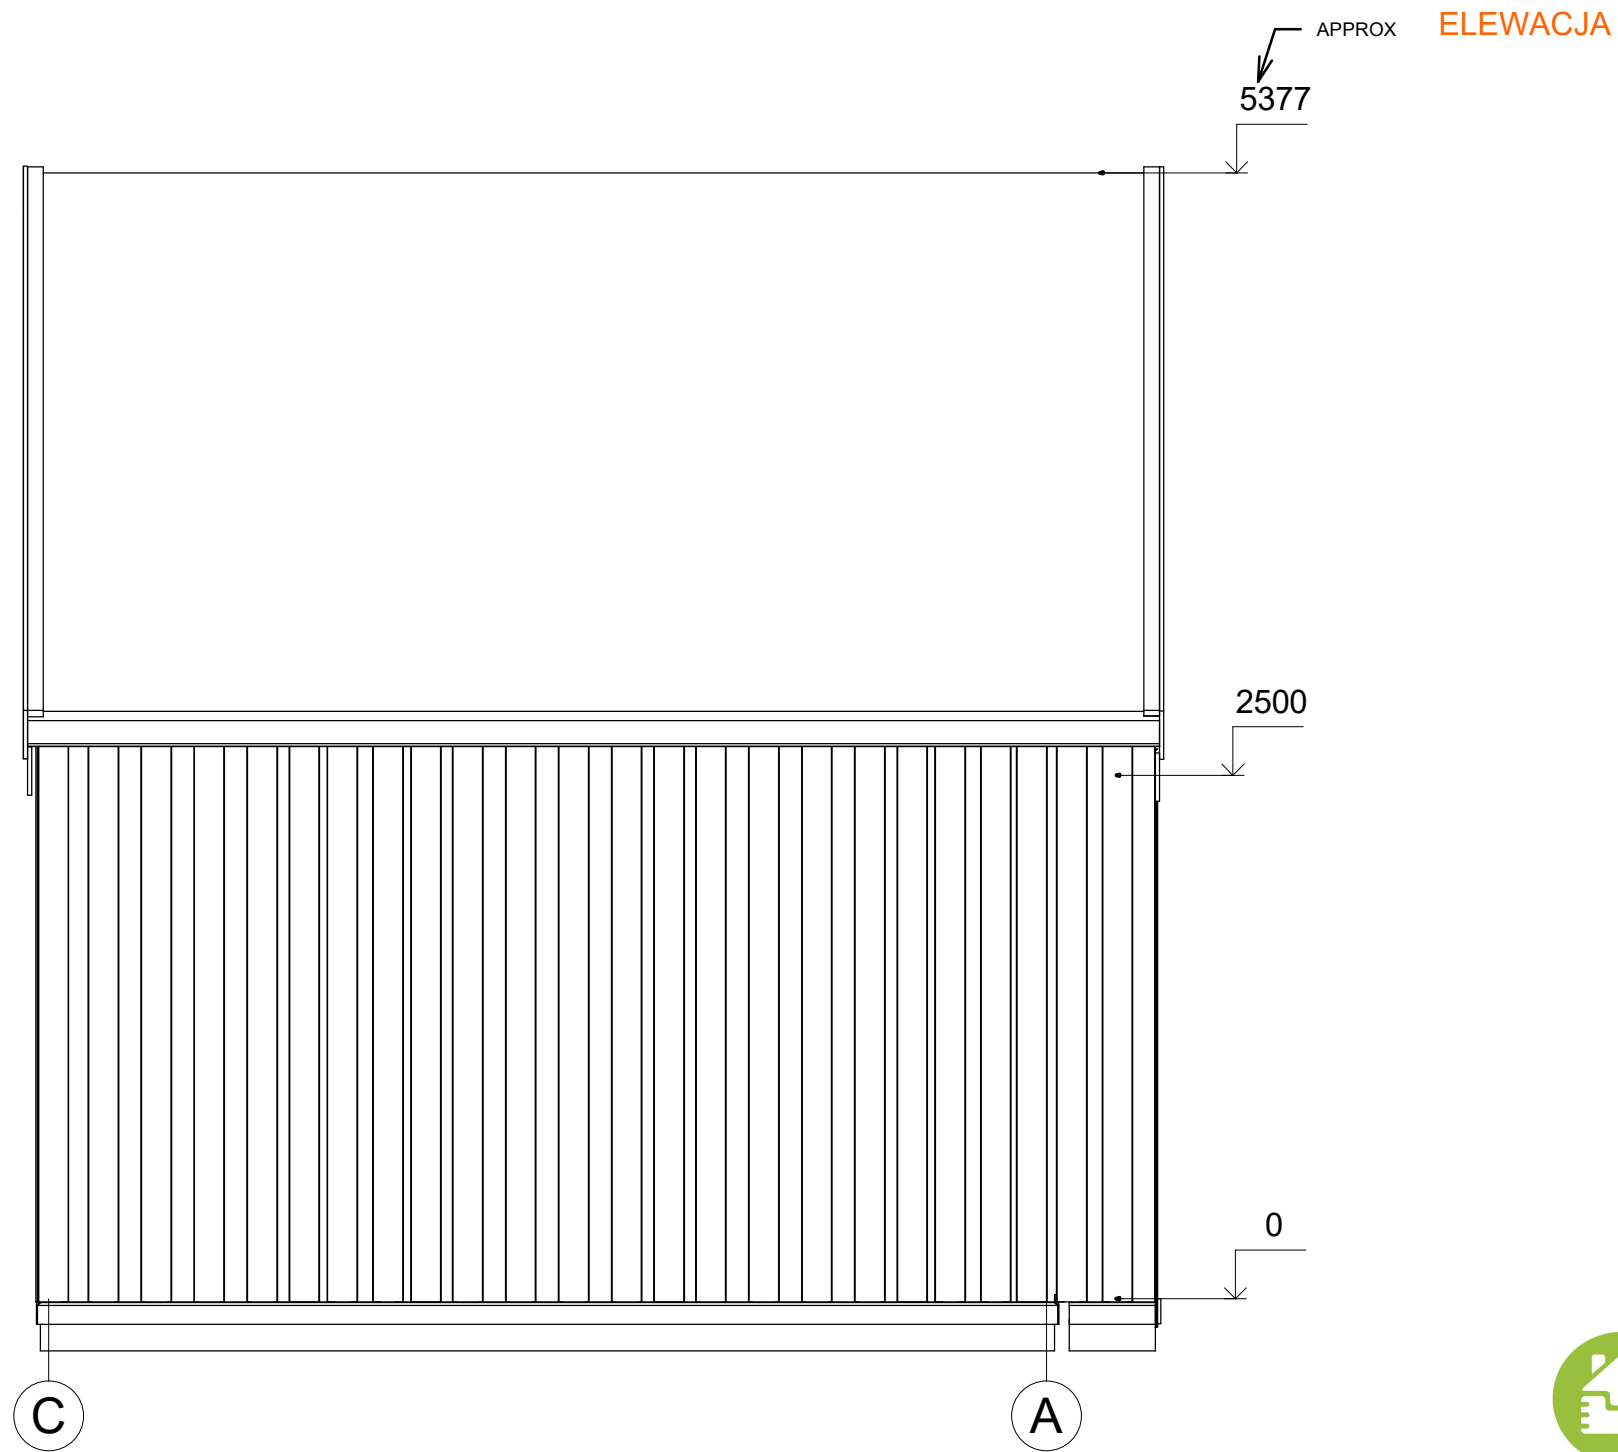

All interior area	28.8 m2	Profile	S100_A1	Project	V1_A1_THERMO_4x5.3_S100	Scale
All roof area	35.0 m2	All terrace	1.7 m2	2023-01-16 19:40:58	Drawing name	FACADE CA
						1 : 37