



**Dom 91 m<sup>2</sup> mieszkalny,  
modułowy, całoroczny JANTAR  
V4\_A1**

**11,6x6,9 m, DOM MIESZKALNY  
W STANIE DEWELOPERSKIM\_WT  
2021, Ciepła płyta  
fundamentowa + system  
ociepleń PRO + stolarka 3  
szybowe PVC + trzykrotne  
malowana elewacja + pokrycie  
dachu i orynowanie +  
instalacja elektryczna, wodno-  
kanalizacyjna + wykończenie  
ścian wewnętrznych, sufitów +  
dostawa i montaż zestawu**

Produkt

#V4\_A1\_11,6x6,9\_DOMMIESZKALNYWSTANIED  
EWELOPERSKIM\_WT2021\_Ciepłapł

**355200.00 zł**

<https://domyekoarchitektura.pl/dom-91-m2-mieszkalny-modulowy-caloroczny-jantar-v4-a1>




Tel.: +48 856 723 031

Kontakt mailowy: [sklep@domyekoarchitektura.pl](mailto:sklep@domyekoarchitektura.pl)  
[www.domyekoarchitektura.pl](http://www.domyekoarchitektura.pl)




|                   |         |             |         |                     |                               |       |
|-------------------|---------|-------------|---------|---------------------|-------------------------------|-------|
| All interior area | 91.0 m2 | Profile     | S100_A1 | Project             | V4_A1_PRO_11.6x6.9_S100       | Scale |
| All roof area     | 93.6 m2 | All terrace | -       | 2025-09-28 10:43:50 | Drawing name 3D VISUALIZATION |       |

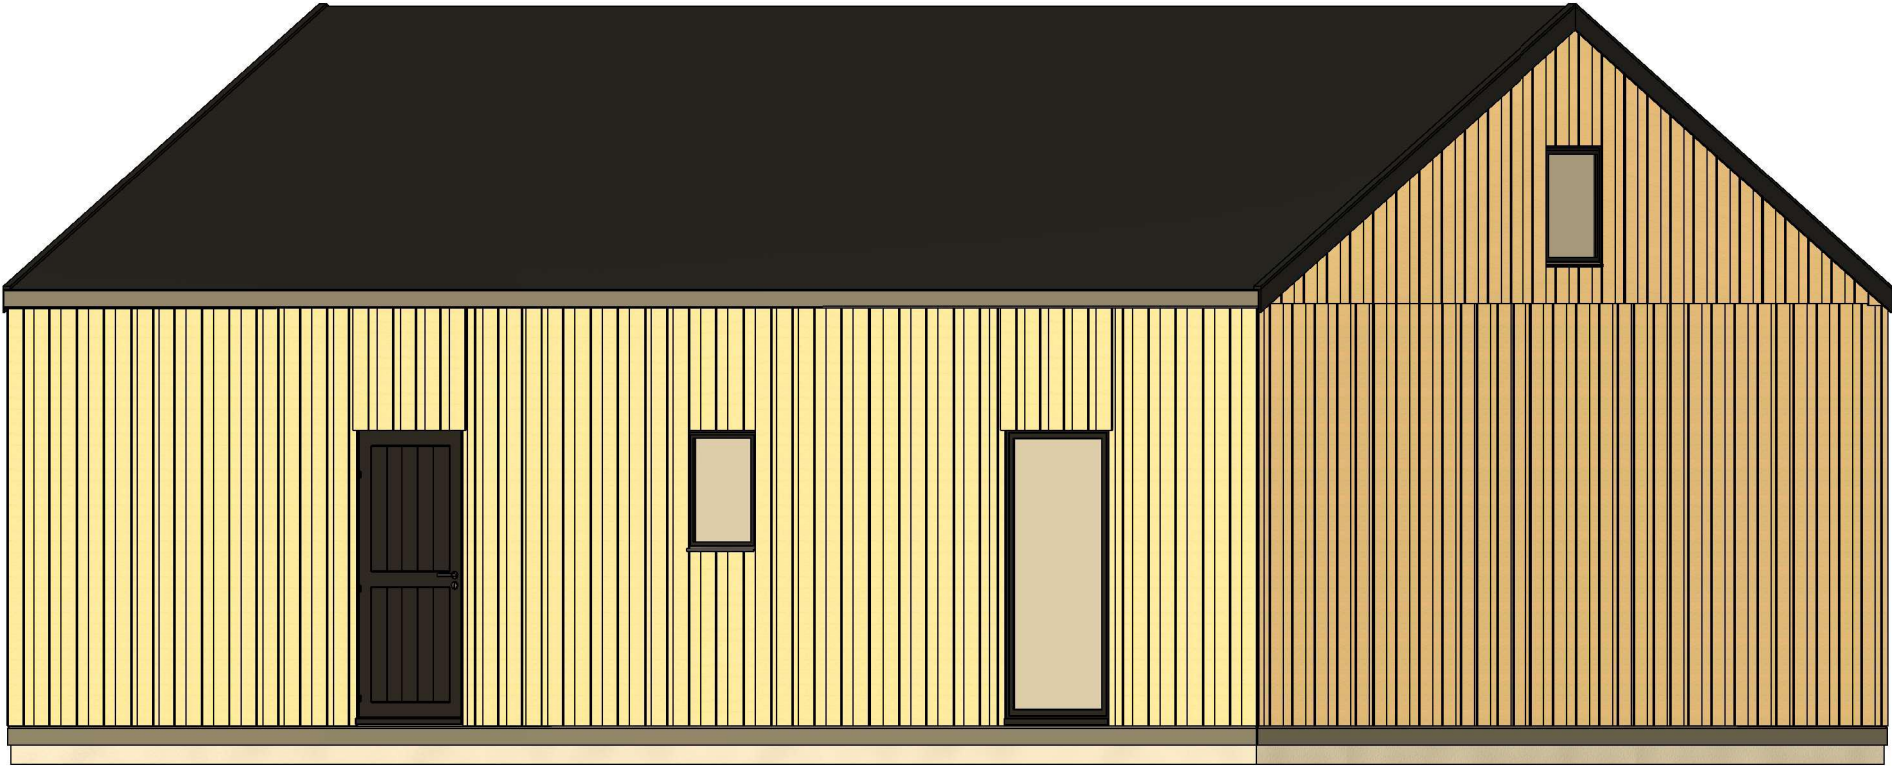


|                   |         |             |         |                     |                               |       |
|-------------------|---------|-------------|---------|---------------------|-------------------------------|-------|
| All interior area | 91.0 m2 | Profile     | S100_A1 | Project             | V4_A1_PRO_11.6x6.9_S100       | Scale |
| All roof area     | 93.6 m2 | All terrace | -       | 2025-09-28 10:43:52 | Drawing name 3D VISUALIZATION |       |

RZUT PLANU

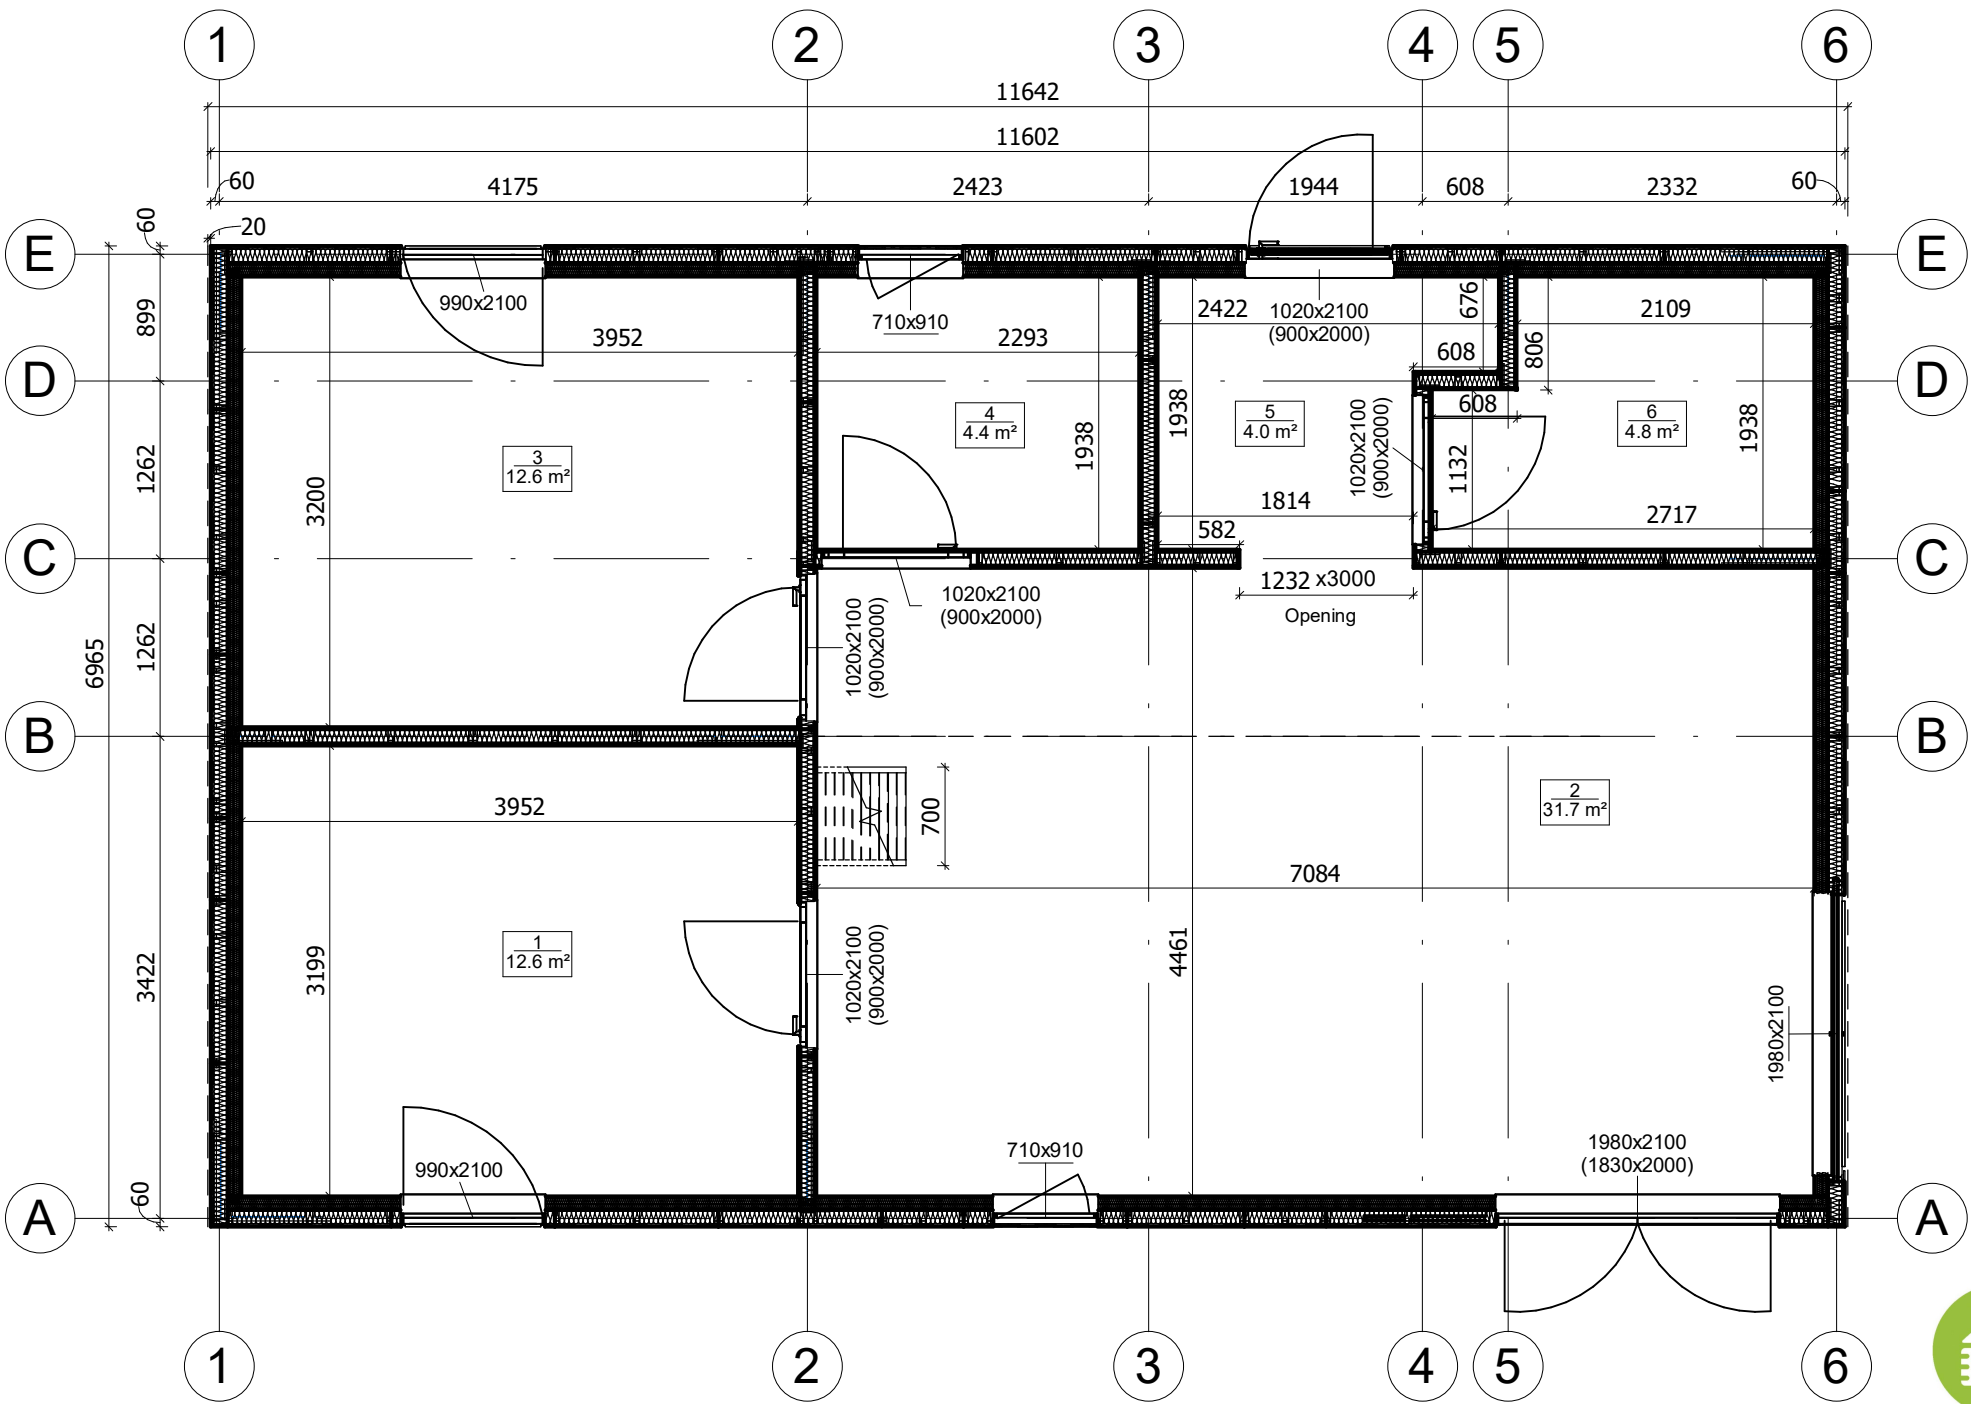


|                   |         |             |         |                     |                           |        |
|-------------------|---------|-------------|---------|---------------------|---------------------------|--------|
| All interior area | 91.0 m2 | Profile     | S100_A1 | Project             | V4_A1_PRO_11.6x6.9_S100   | Scale  |
| All roof area     | 93.6 m2 | All terrace | -       | 2025-09-28 10:44:42 | Drawing name 1 FLOOR PLAN | 1 : 55 |

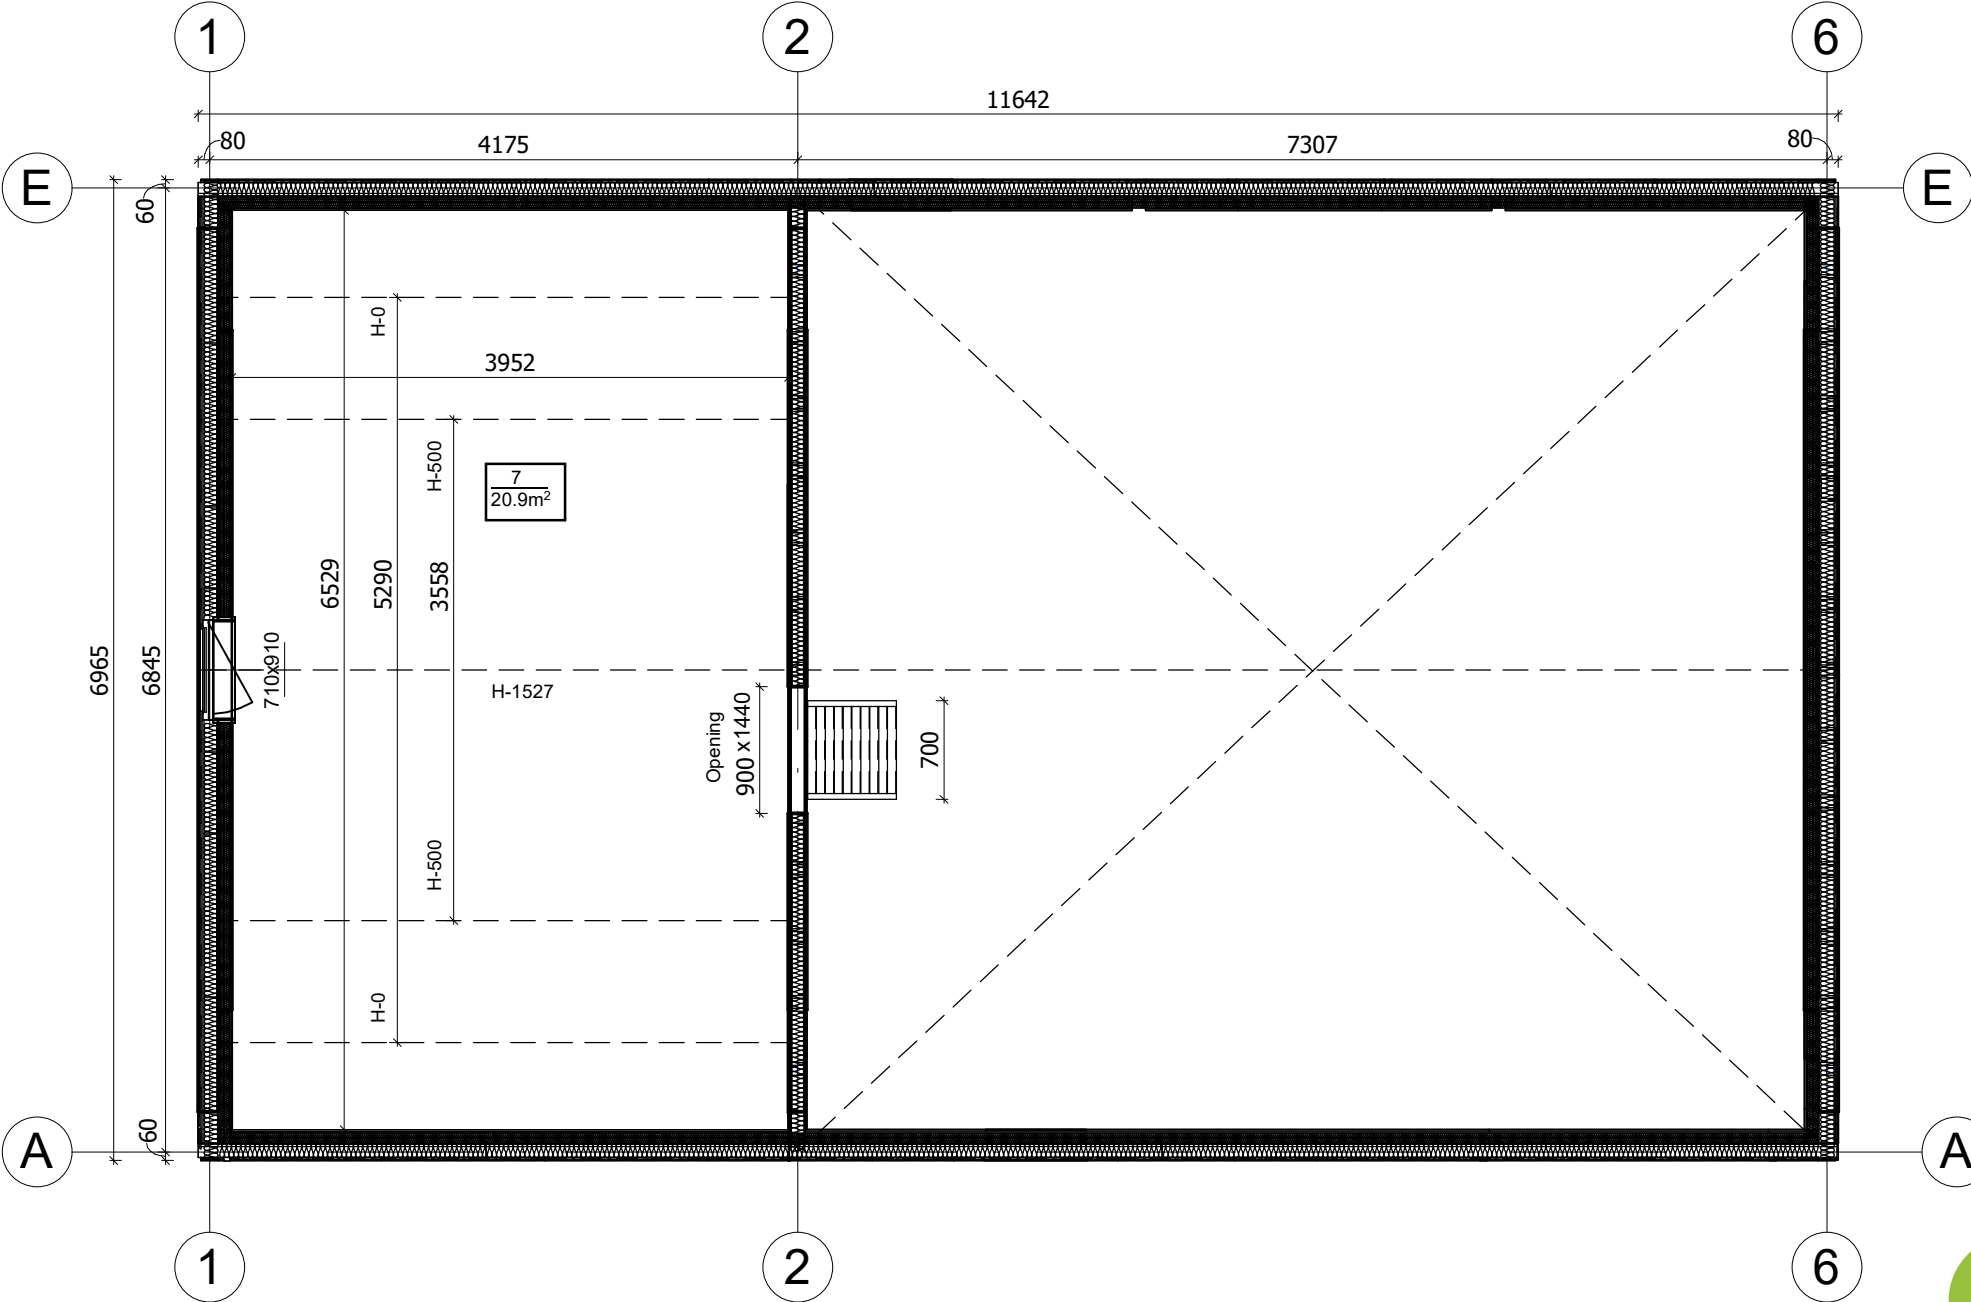

|                   |         |             |         |                     |                           |        |
|-------------------|---------|-------------|---------|---------------------|---------------------------|--------|
| All interior area | 91.0 m2 | Profile     | S100_A1 | Project             | V4_A1_PRO_11.6x6.9_S100   | Scale  |
| All roof area     | 93.6 m2 | All terrace | -       | 2025-09-28 10:44:46 | Drawing name 2 FLOOR PLAN | 1 : 55 |

# PRZEKROJ

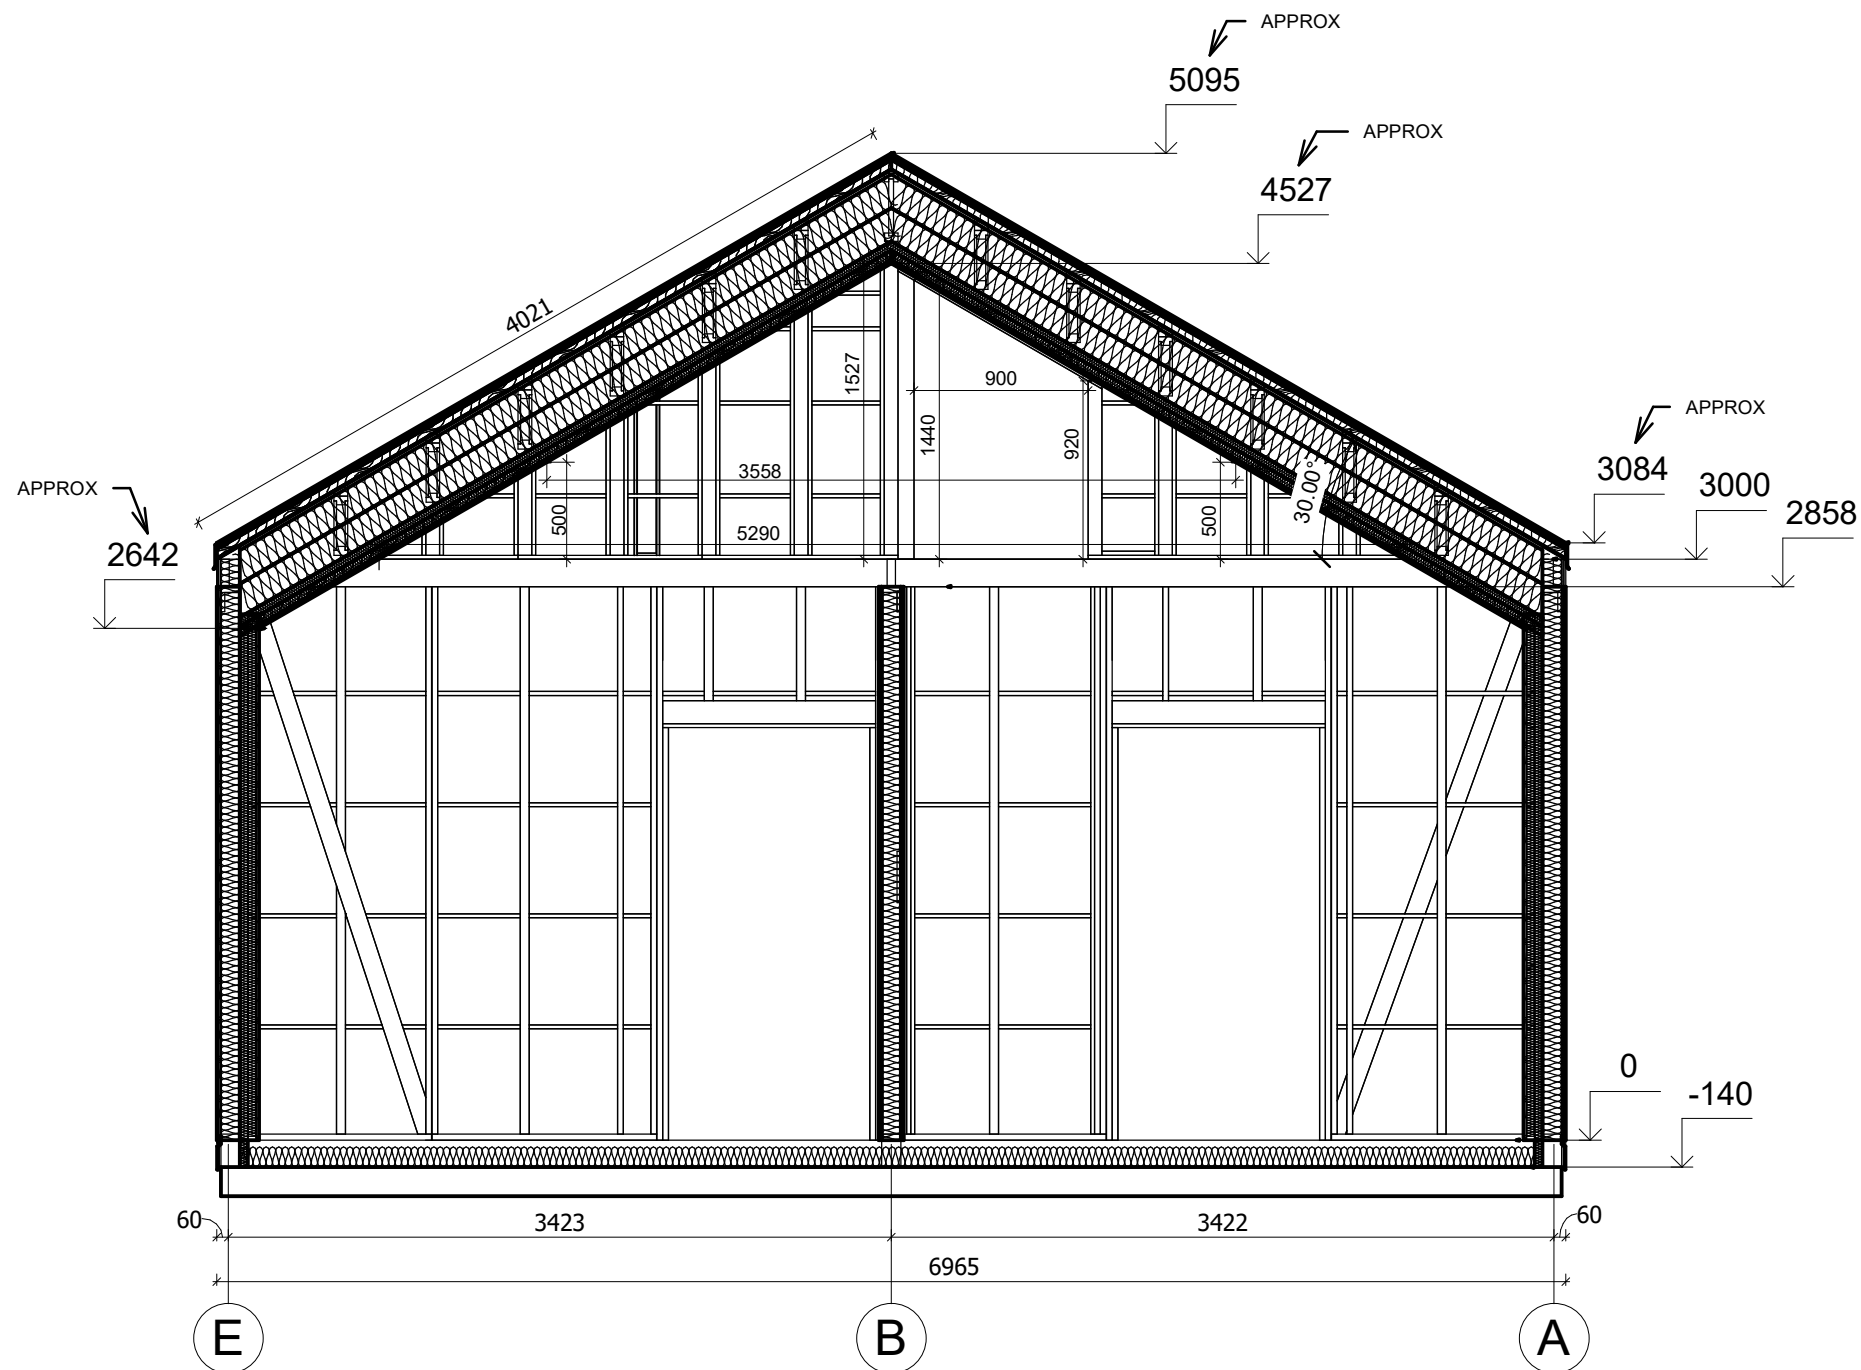

|                   |         |             |         |                     |                         |                       |
|-------------------|---------|-------------|---------|---------------------|-------------------------|-----------------------|
| All interior area | 91.0 m2 | Profile     | S100_A1 | Project             | V4_A1_PRO_11.6x6.9_S100 | Scale                 |
| All roof area     | 93.6 m2 | All terrace | -       | 2025-09-28 09:49:25 | Drawing name            | VERTICAL SECTION 2-EA |
|                   |         |             |         |                     |                         | 1 : 40                |