



**Dom 97 m<sup>2</sup> mieszkalny,  
modułowy, całoroczny ANTONIN  
V17\_A1**

**9,8 x 7,1 m, DOM MIESZKALNY  
W STANIE DEWELOPERSKIM\_WT  
2021, Ciepła płyta  
fundamentowa + system  
ociepleń PRO + stolarka 3  
szybowe PVC + trzykrotne  
malowana elewacja + pokrycie  
dachu i orynowanie +  
instalacja elektryczna, wodno-  
kanalizacyjna + wykończenie  
ścian wewnętrznych, sufitów +  
dostawa i montaż zestawu**

Produkt

#V17\_A1\_9,8x7,1\_DOMMIESZKALNYWSTANIED  
EWELOPERSKIM\_WT2021\_Ciepłapł

**433670.00 zł**

<https://domyekoarchitektura.pl/dom-97-m2-mieszkalny-modulowy-caloroczny-antonin-v17-a1>



Tel.: +48 856 723 031

Kontakt mailowy: [sklep@domyekoarchitektura.pl](mailto:sklep@domyekoarchitektura.pl)  
[www.domyekoarchitektura.pl](http://www.domyekoarchitektura.pl)




|                   |         |             |         |                        |                               |       |
|-------------------|---------|-------------|---------|------------------------|-------------------------------|-------|
| All interior area | 96.8 m2 | Profile     | S100_A1 | Project                | V17_A1_THERMO_9.7x7_S100      | Scale |
| All roof area     | 98.2 m2 | All terrace |         | 2025-11-14<br>04:09:54 | Drawing name 3D VISUALIZATION |       |




|                   |         |             |         |                     |                               |       |
|-------------------|---------|-------------|---------|---------------------|-------------------------------|-------|
| All interior area | 96.8 m2 | Profile     | S100_A1 | Project             | V17_A1_THERMO_9.7x7_S100      | Scale |
| All roof area     | 98.2 m2 | All terrace |         | 2025-11-14 04:09:55 | Drawing name 3D VISUALIZATION |       |

# RZUT PLANU

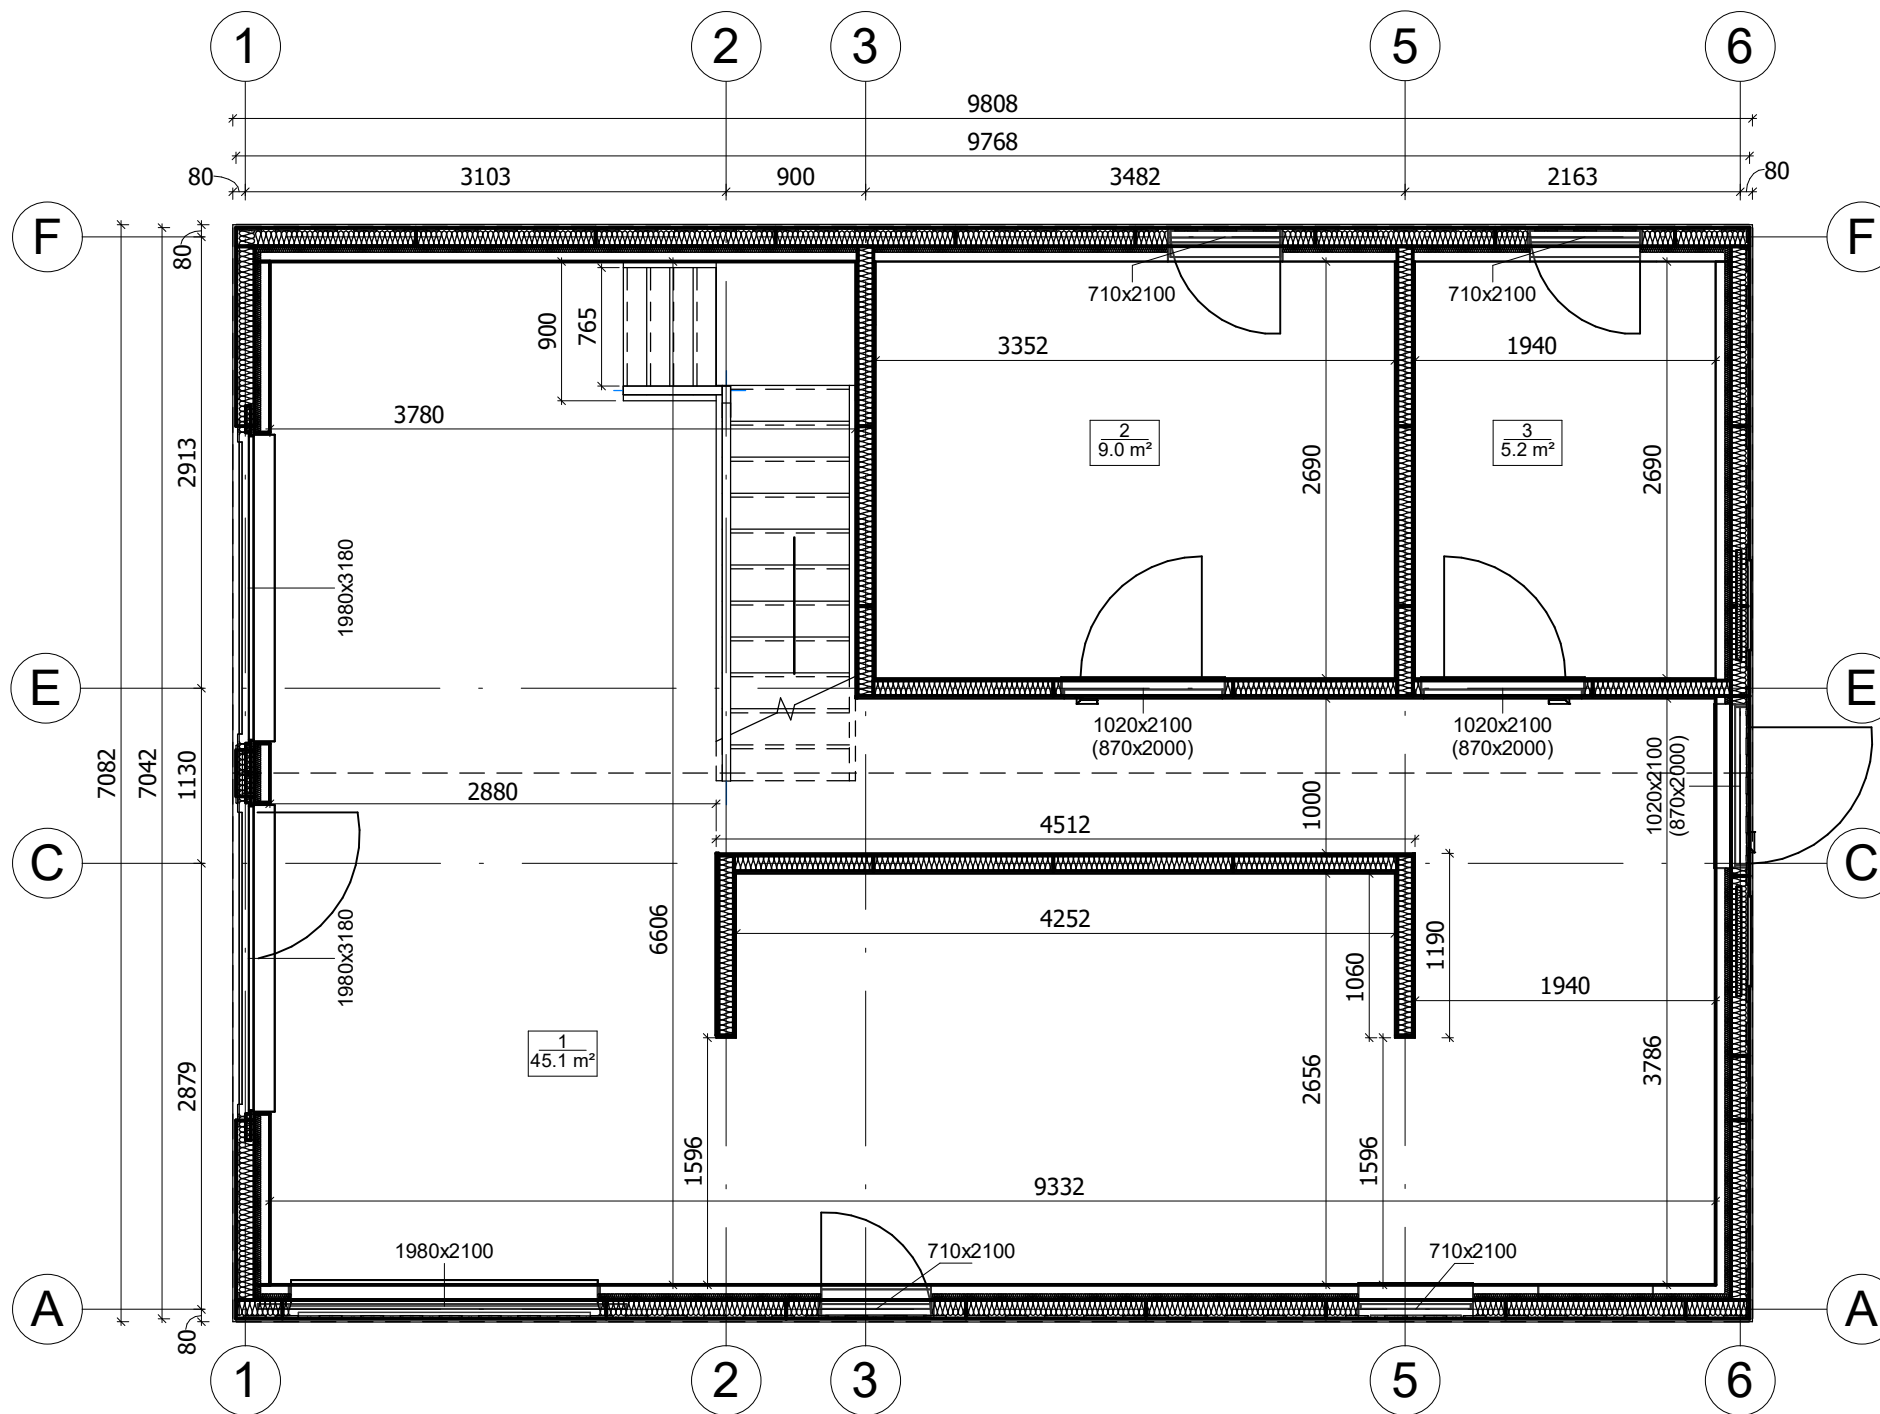


|                   |         |             |         |                     |                           |        |  |
|-------------------|---------|-------------|---------|---------------------|---------------------------|--------|--|
| All interior area | 96.8 m2 | Profile     | S100_A1 | Project             | V17_A1_THERMO_9.7x7_S100  | Scale  |  |
| All roof area     | 98.2 m2 | All terrace |         | 2024-10-22 08:21:46 | Drawing name 1 FLOOR PLAN | 1 : 50 |  |

# RZUT PLANU

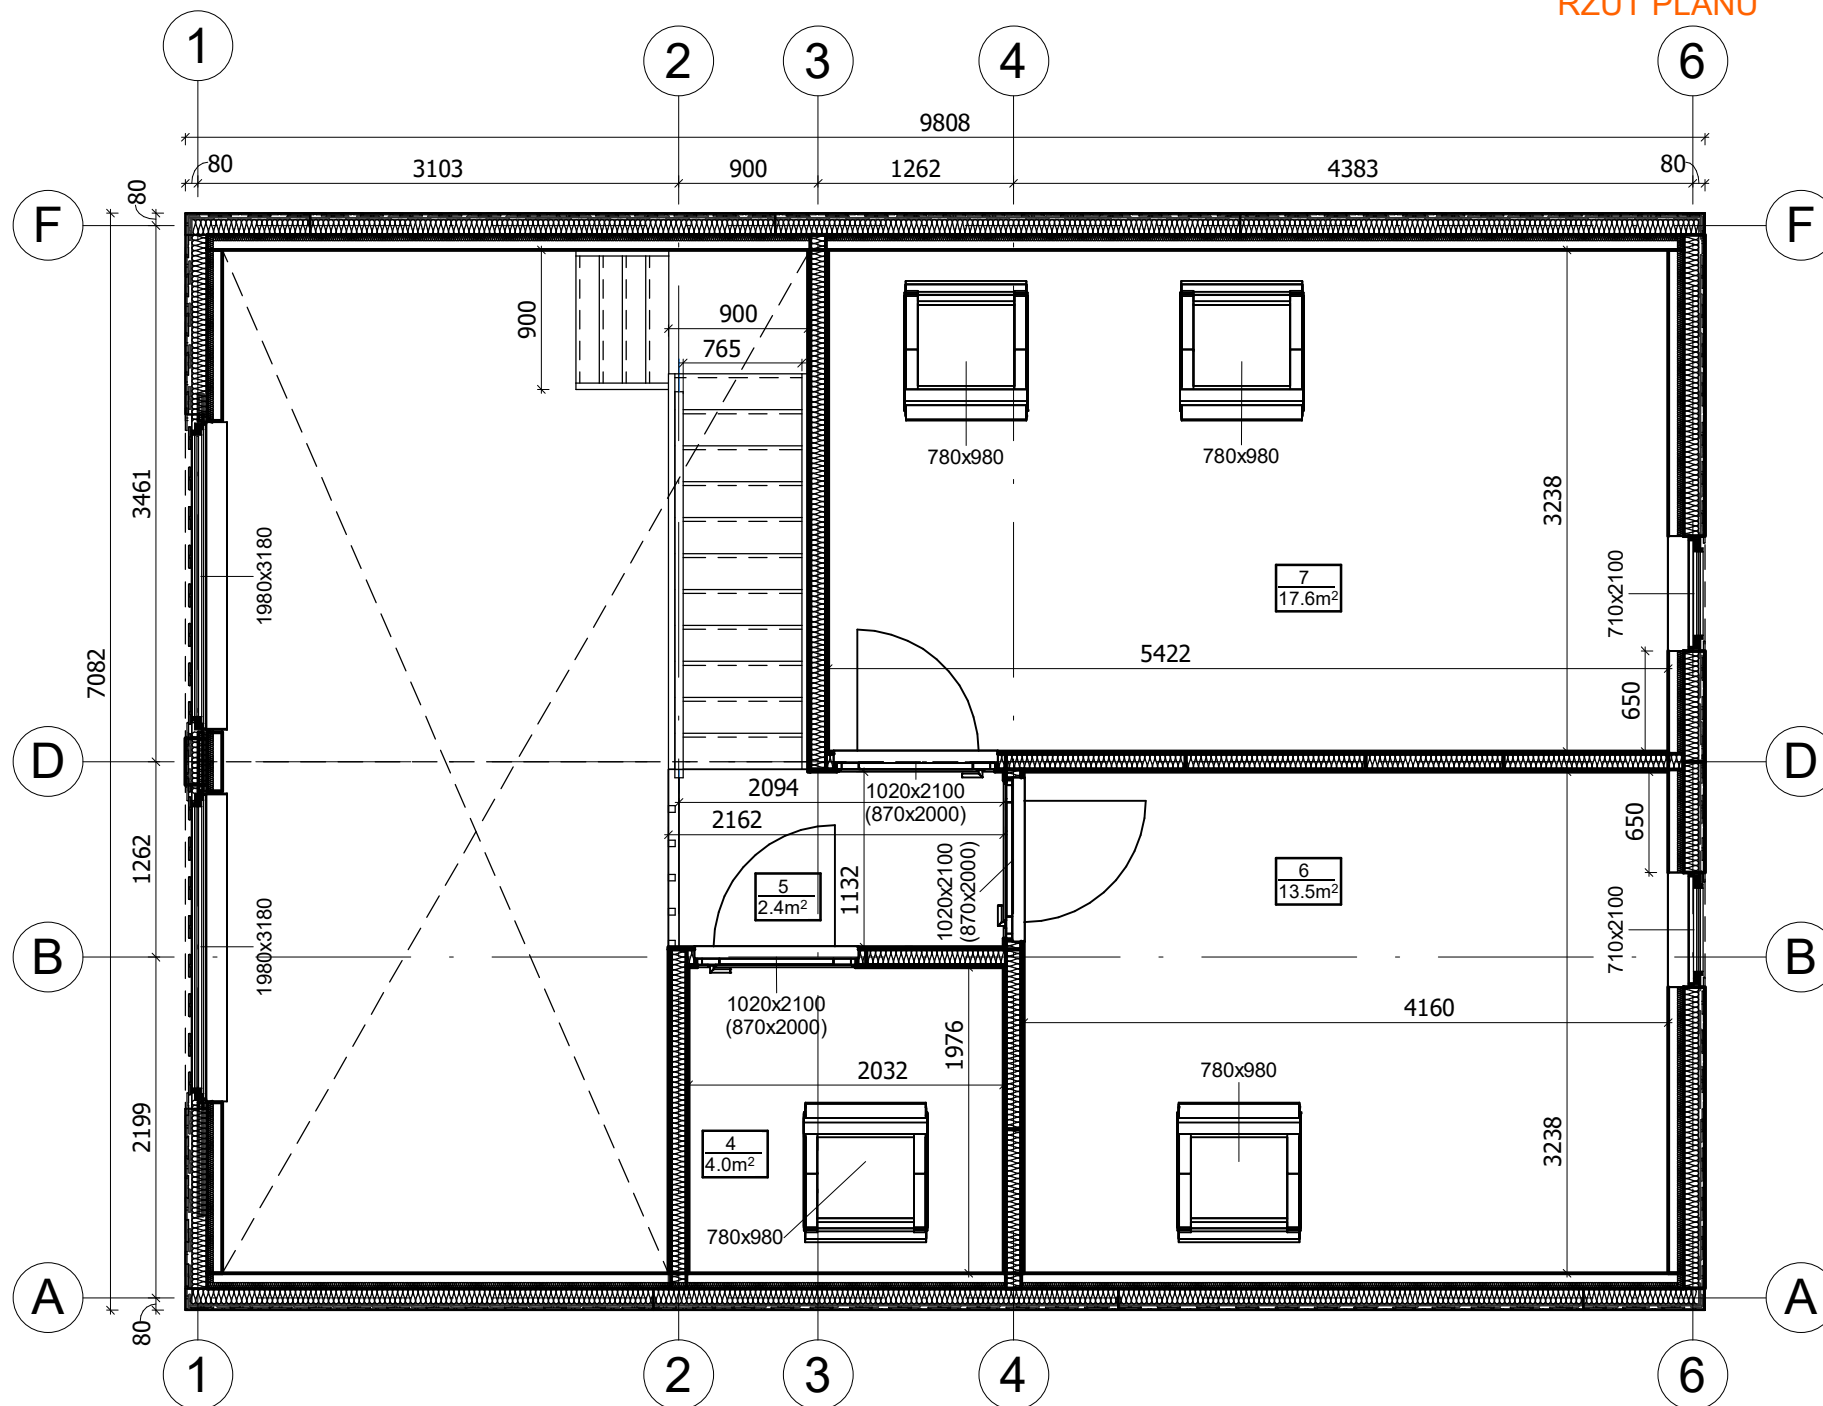

|                   |         |             |         |                     |                          |              |        |
|-------------------|---------|-------------|---------|---------------------|--------------------------|--------------|--------|
| All interior area | 96.8 m2 | Profile     | S100_A1 | Project             | V17_A1_THERMO_9.7x7_S100 | Scale        |        |
| All roof area     | 98.2 m2 | All terrace |         | 2024-10-22 08:21:48 | Drawing name             | 2 FLOOR PLAN | 1 : 50 |

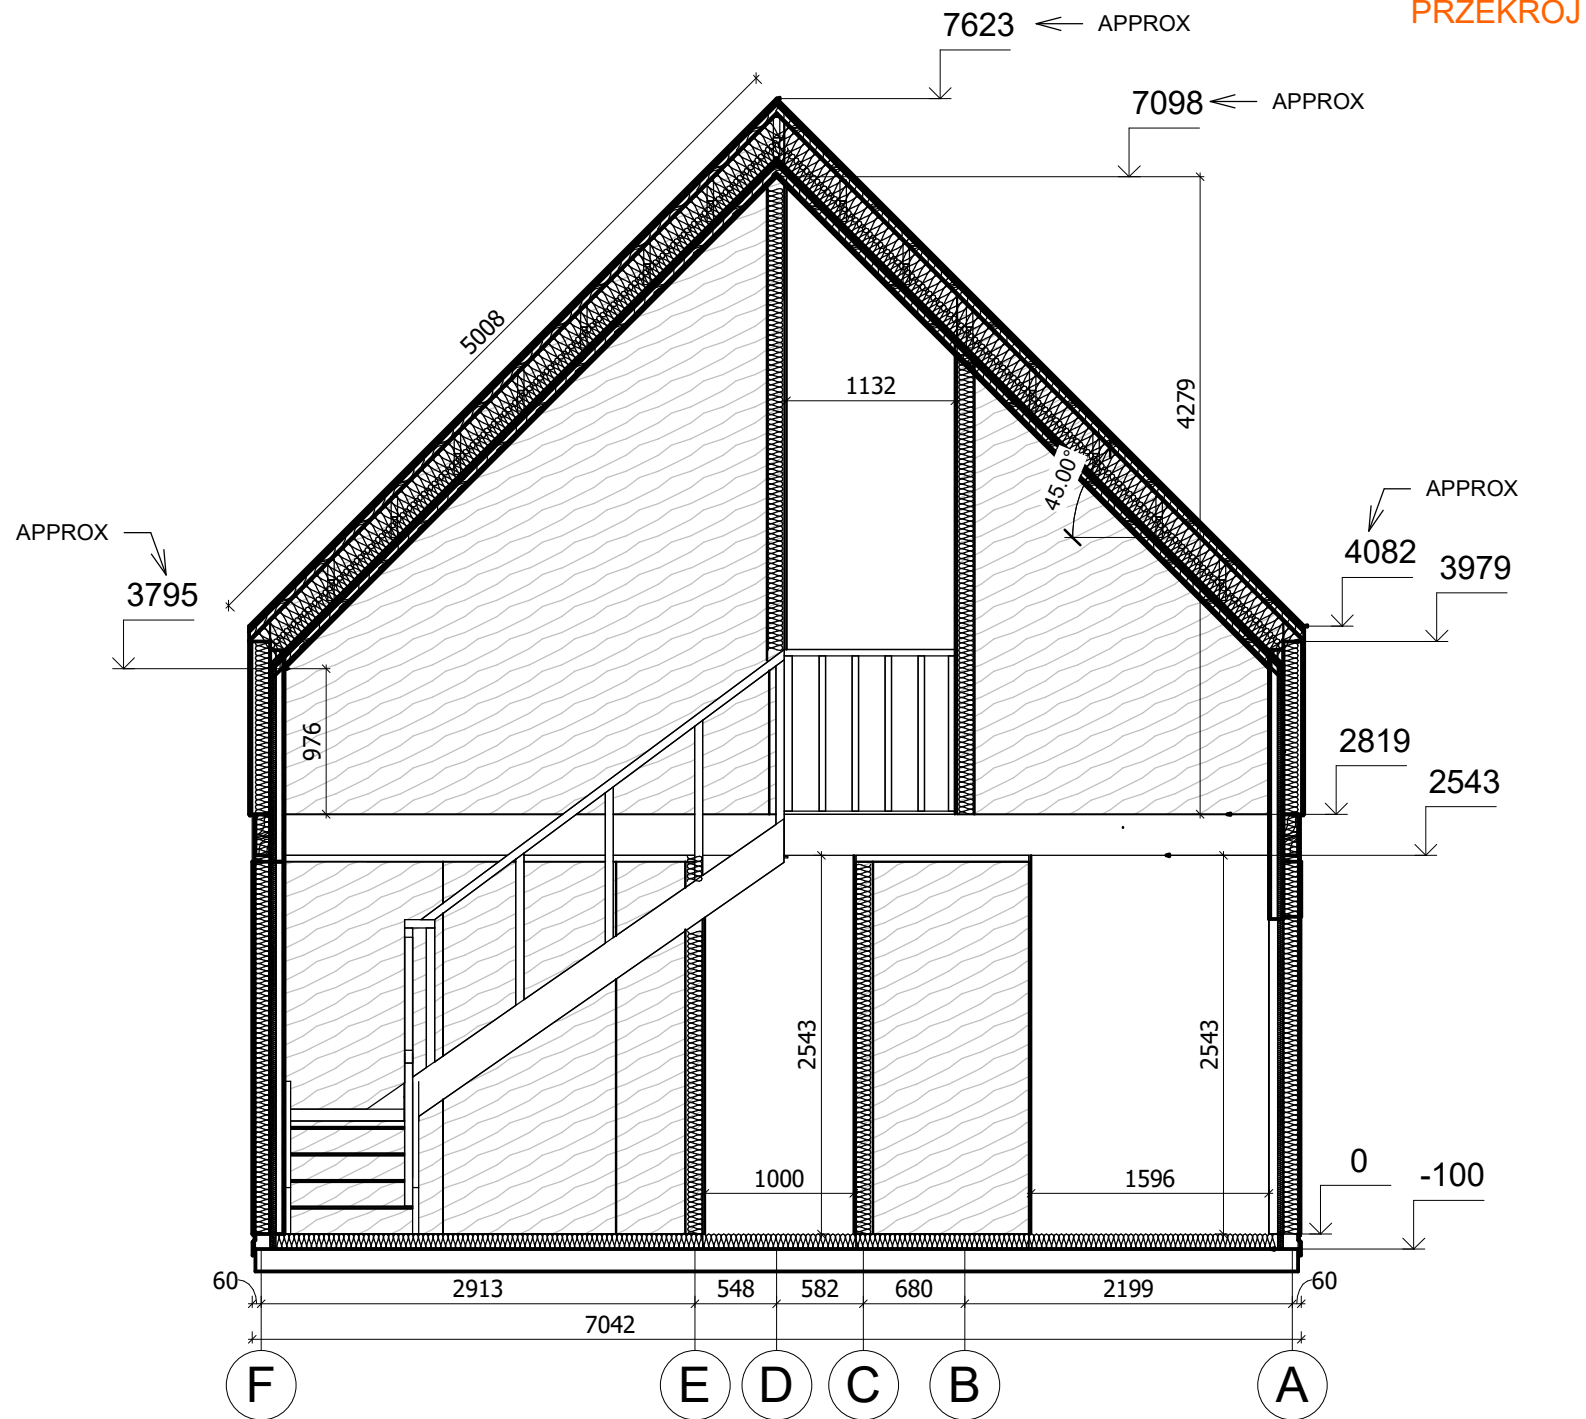

PRZEKROJ



|                   |         |             |         |                     |                                    |        |
|-------------------|---------|-------------|---------|---------------------|------------------------------------|--------|
| All interior area | 96.8 m2 | Profile     | S100_A1 | Project             | V17_A1_THERMO_9.7x7_S100           | Scale  |
| All roof area     | 98.2 m2 | All terrace |         | 2024-10-21 21:11:29 | Drawing name VERTICAL SECTION 2-FA | 1 : 52 |